


NOTE:-

1. MENTIONED BOTTOM OF SLEEVES ARE REFERENCE FROM SSL

GENERAL COORDINATION NOTE:


1. HVAC COORDINATION WITH OTHER MEP SERVICES WILL BE REVIEWED UPON THE RECEIVED RESPONSE OF CASE - 4

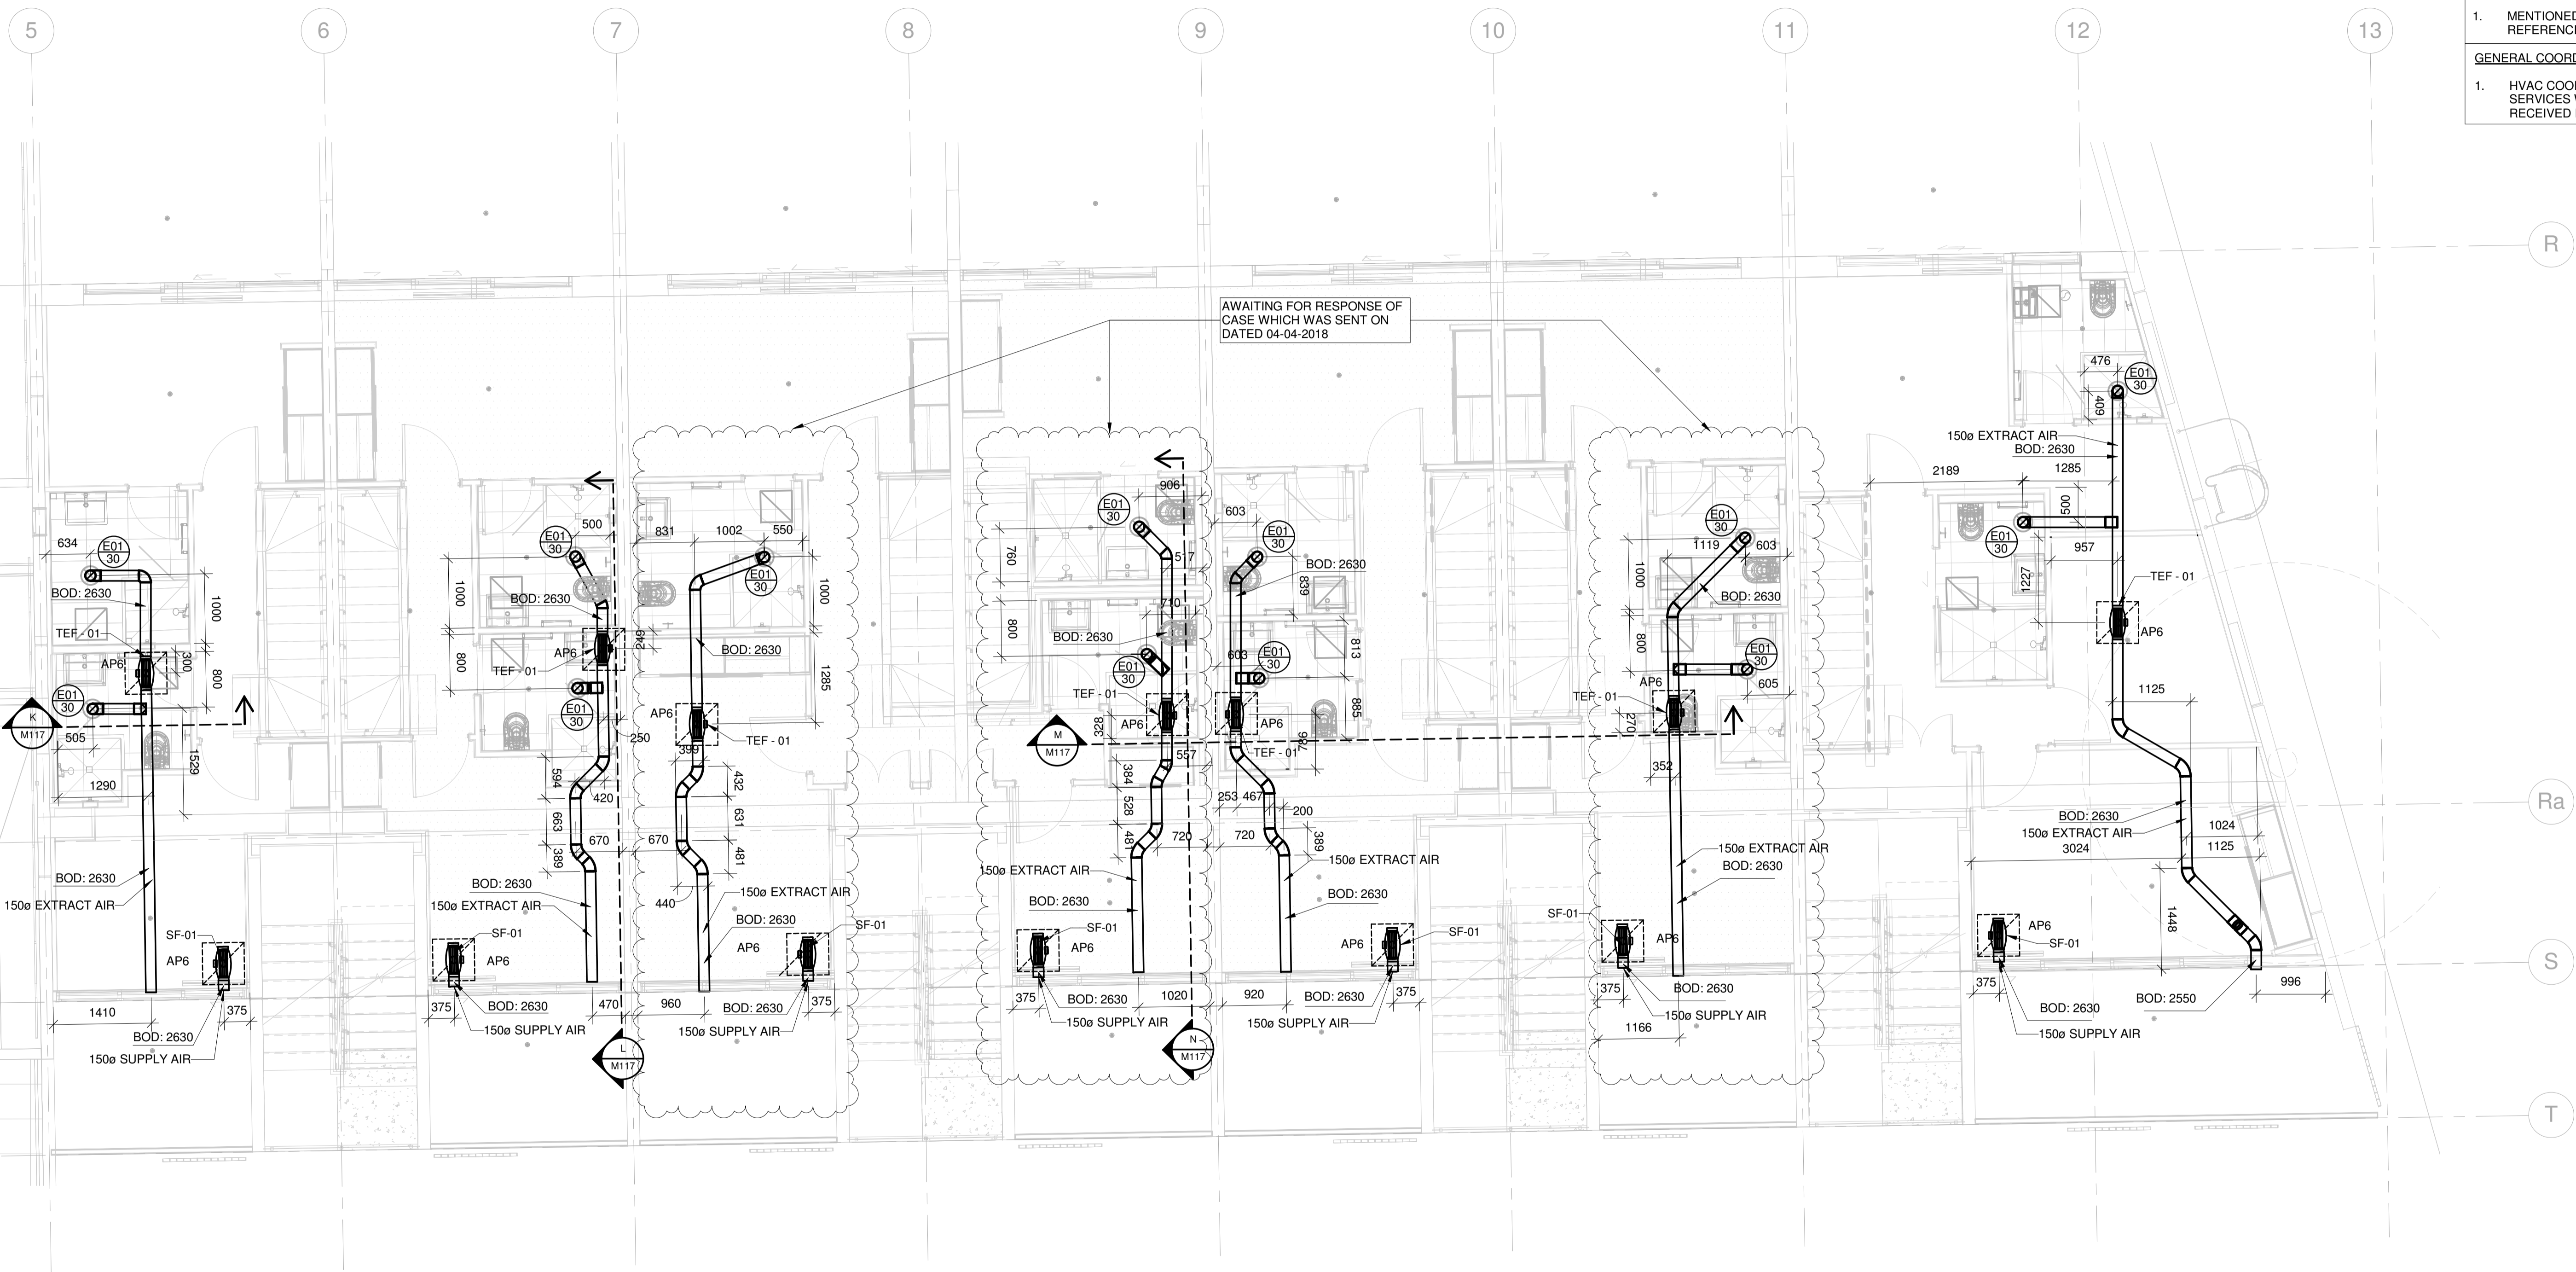


8 GROUND FLOOR BLOCK B HVAC LAYOUT
M116 SCALE : 1 : 50

PROJECT TITLE UNION GREEN APARTMENTS 39 - 47 UNION STREET AUCKLAND CENTRAL	SHEET TITLE GROUND FLOOR BLOCK B HVAC LAYOUT	DESIGNED	IAN	PROJECT NO. 215123	SHEET NO. M116
		DRAWN	RAZIN		
		CHECKED	TRUSHAL		
		DISCIPLINE	MECHANICAL SERVICES	SCALE (A1 ORIGINAL) 1 : 50	REVISION 00


00	FOR APPROVAL	06/04/18	IAN	RAZIN
REV. NO.	REVISION DESCRIPTION	REV. DATE	ENG	CAD

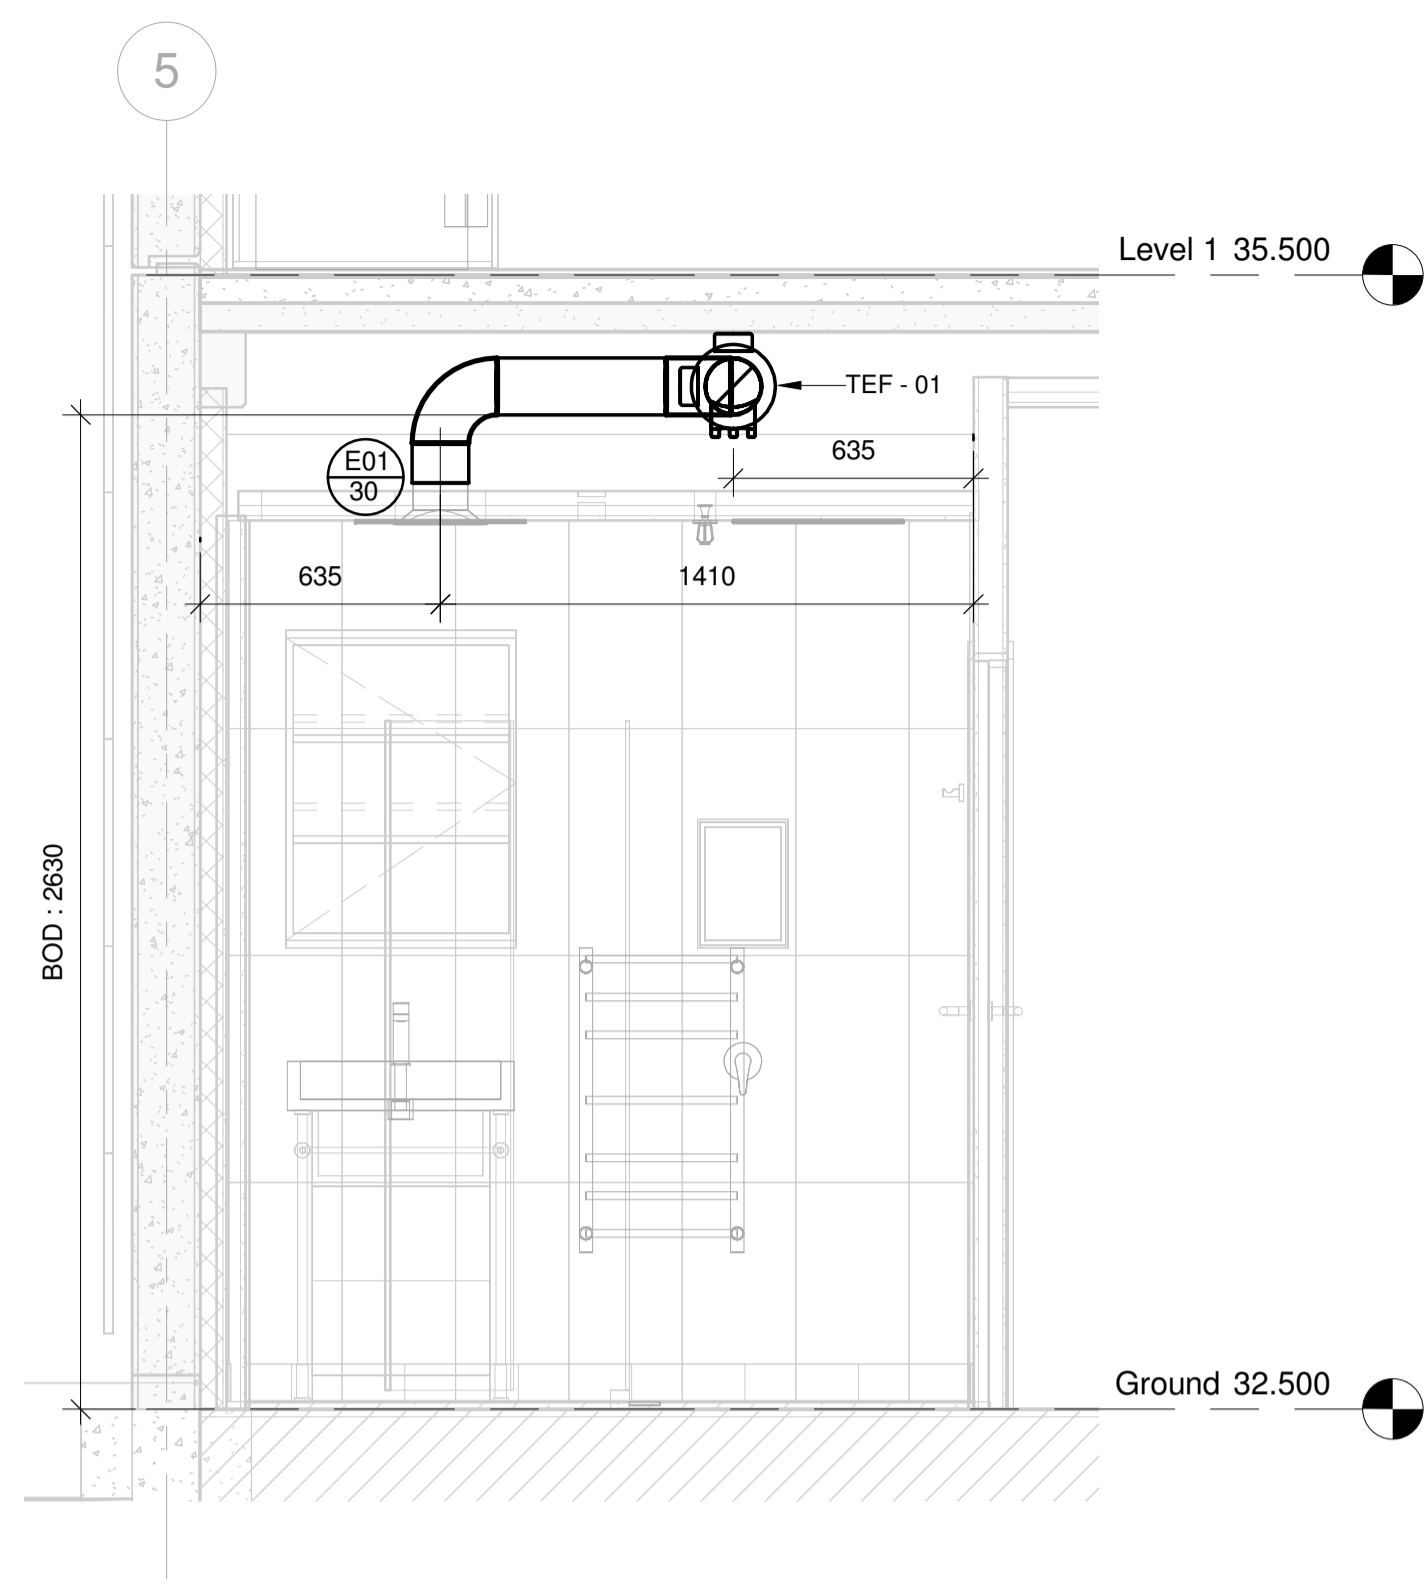


K SECTION K
M117 SCALE : 1 : 20

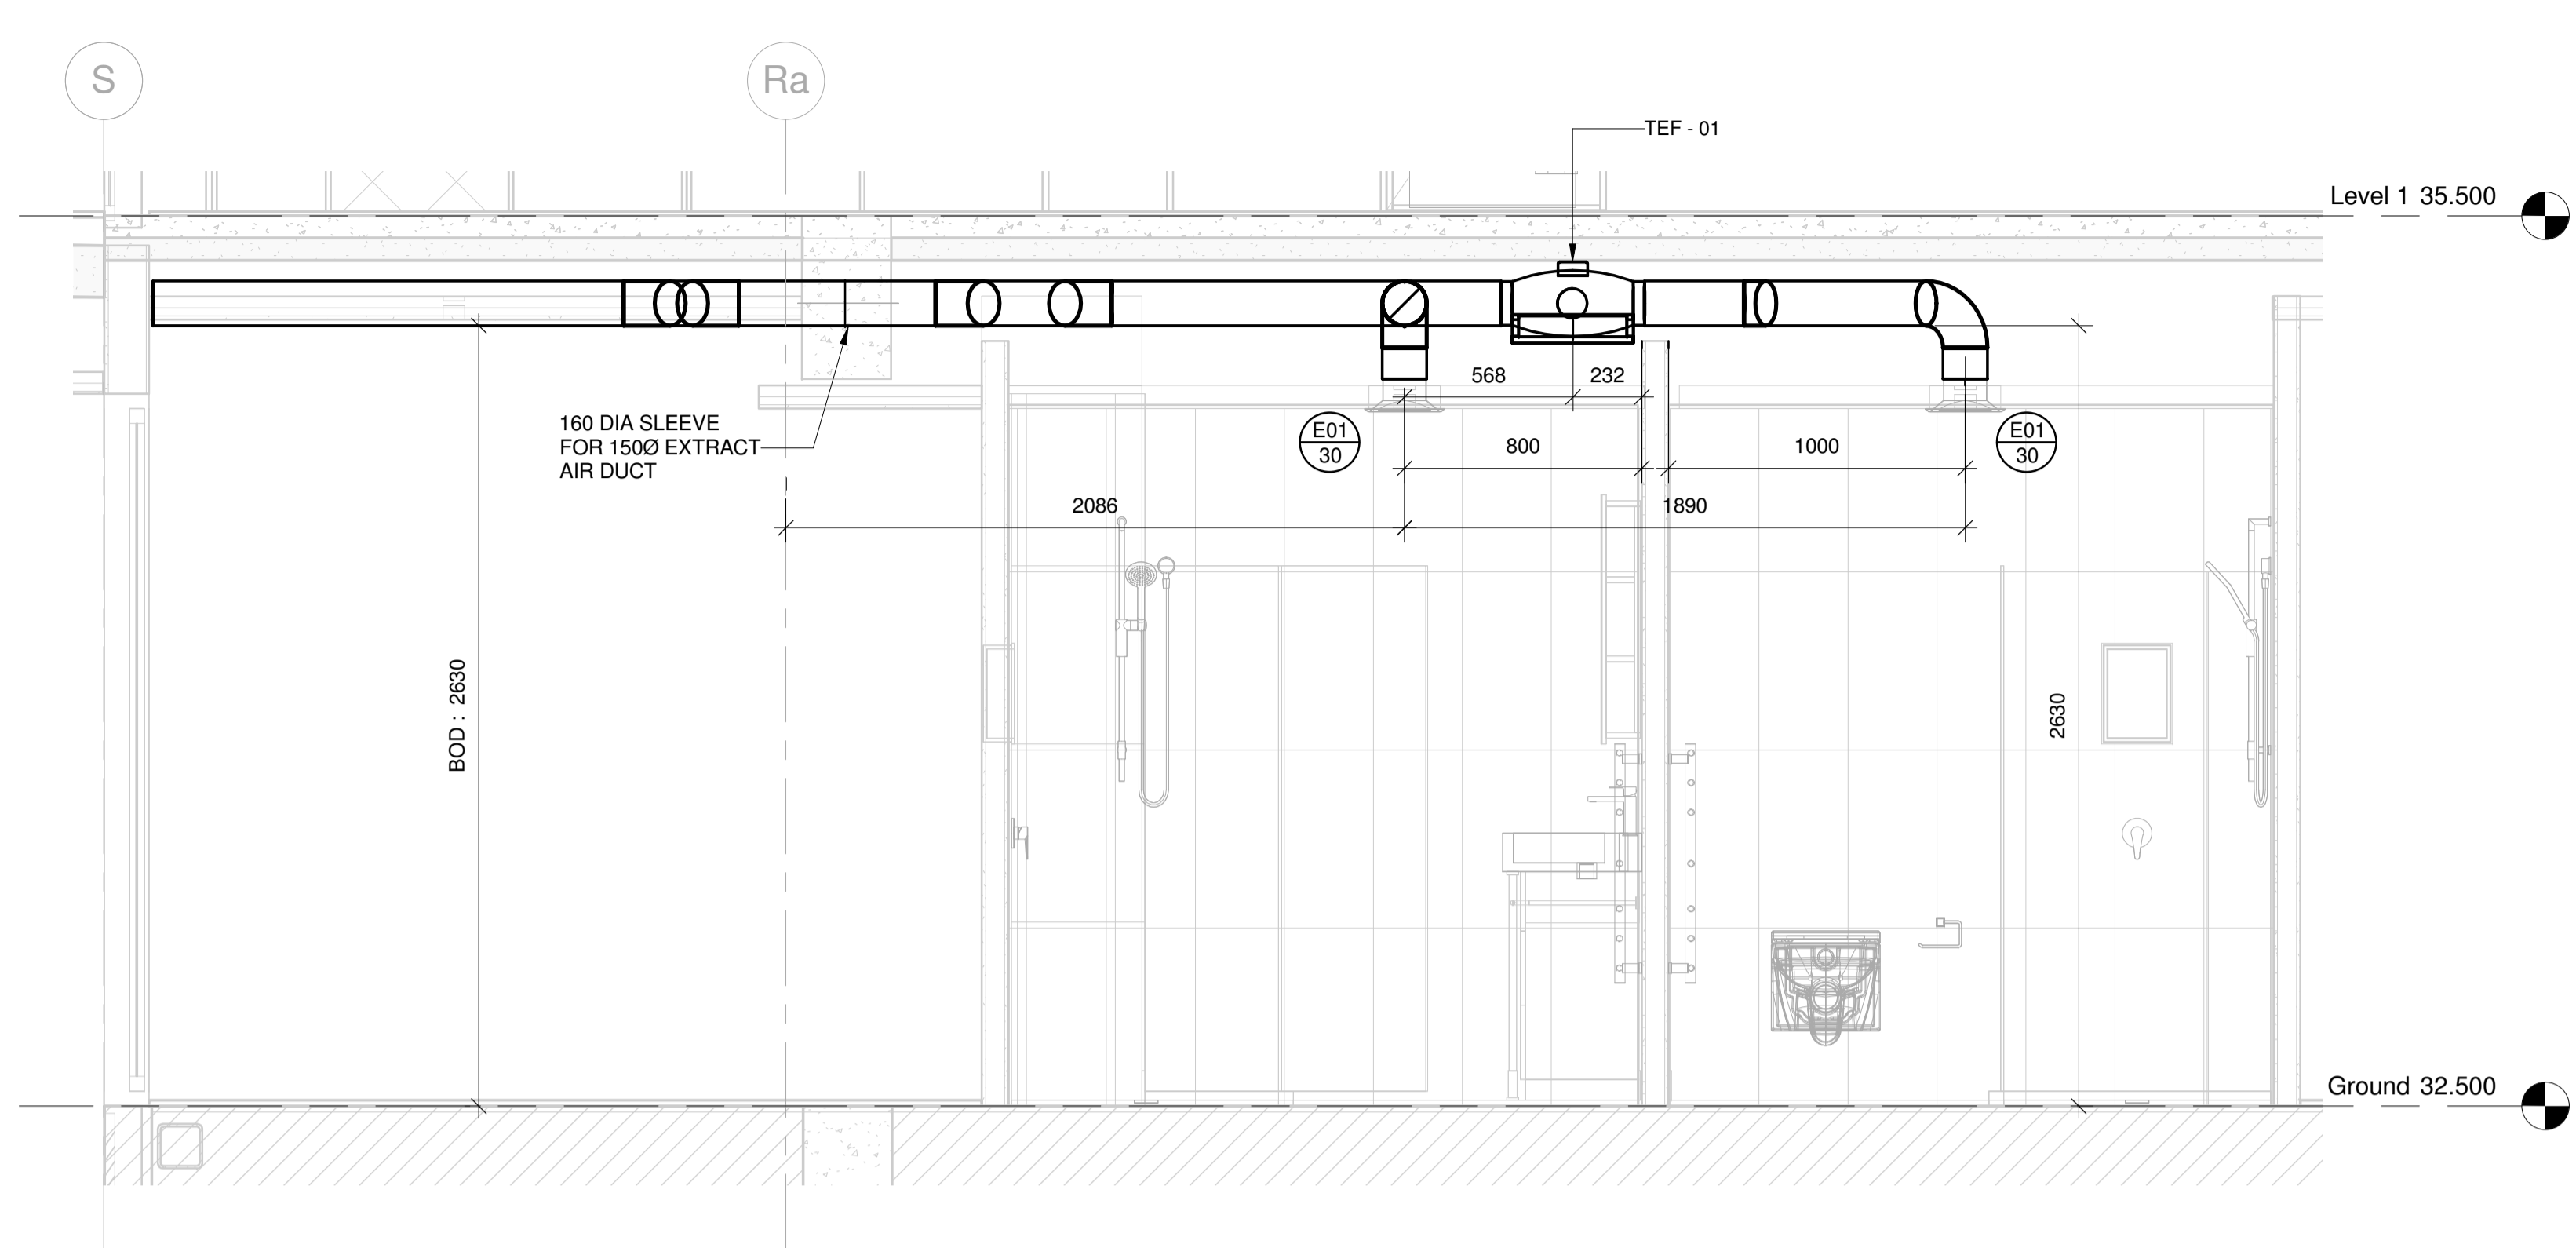


L SECTION L
M117 SCALE : 1 : 20

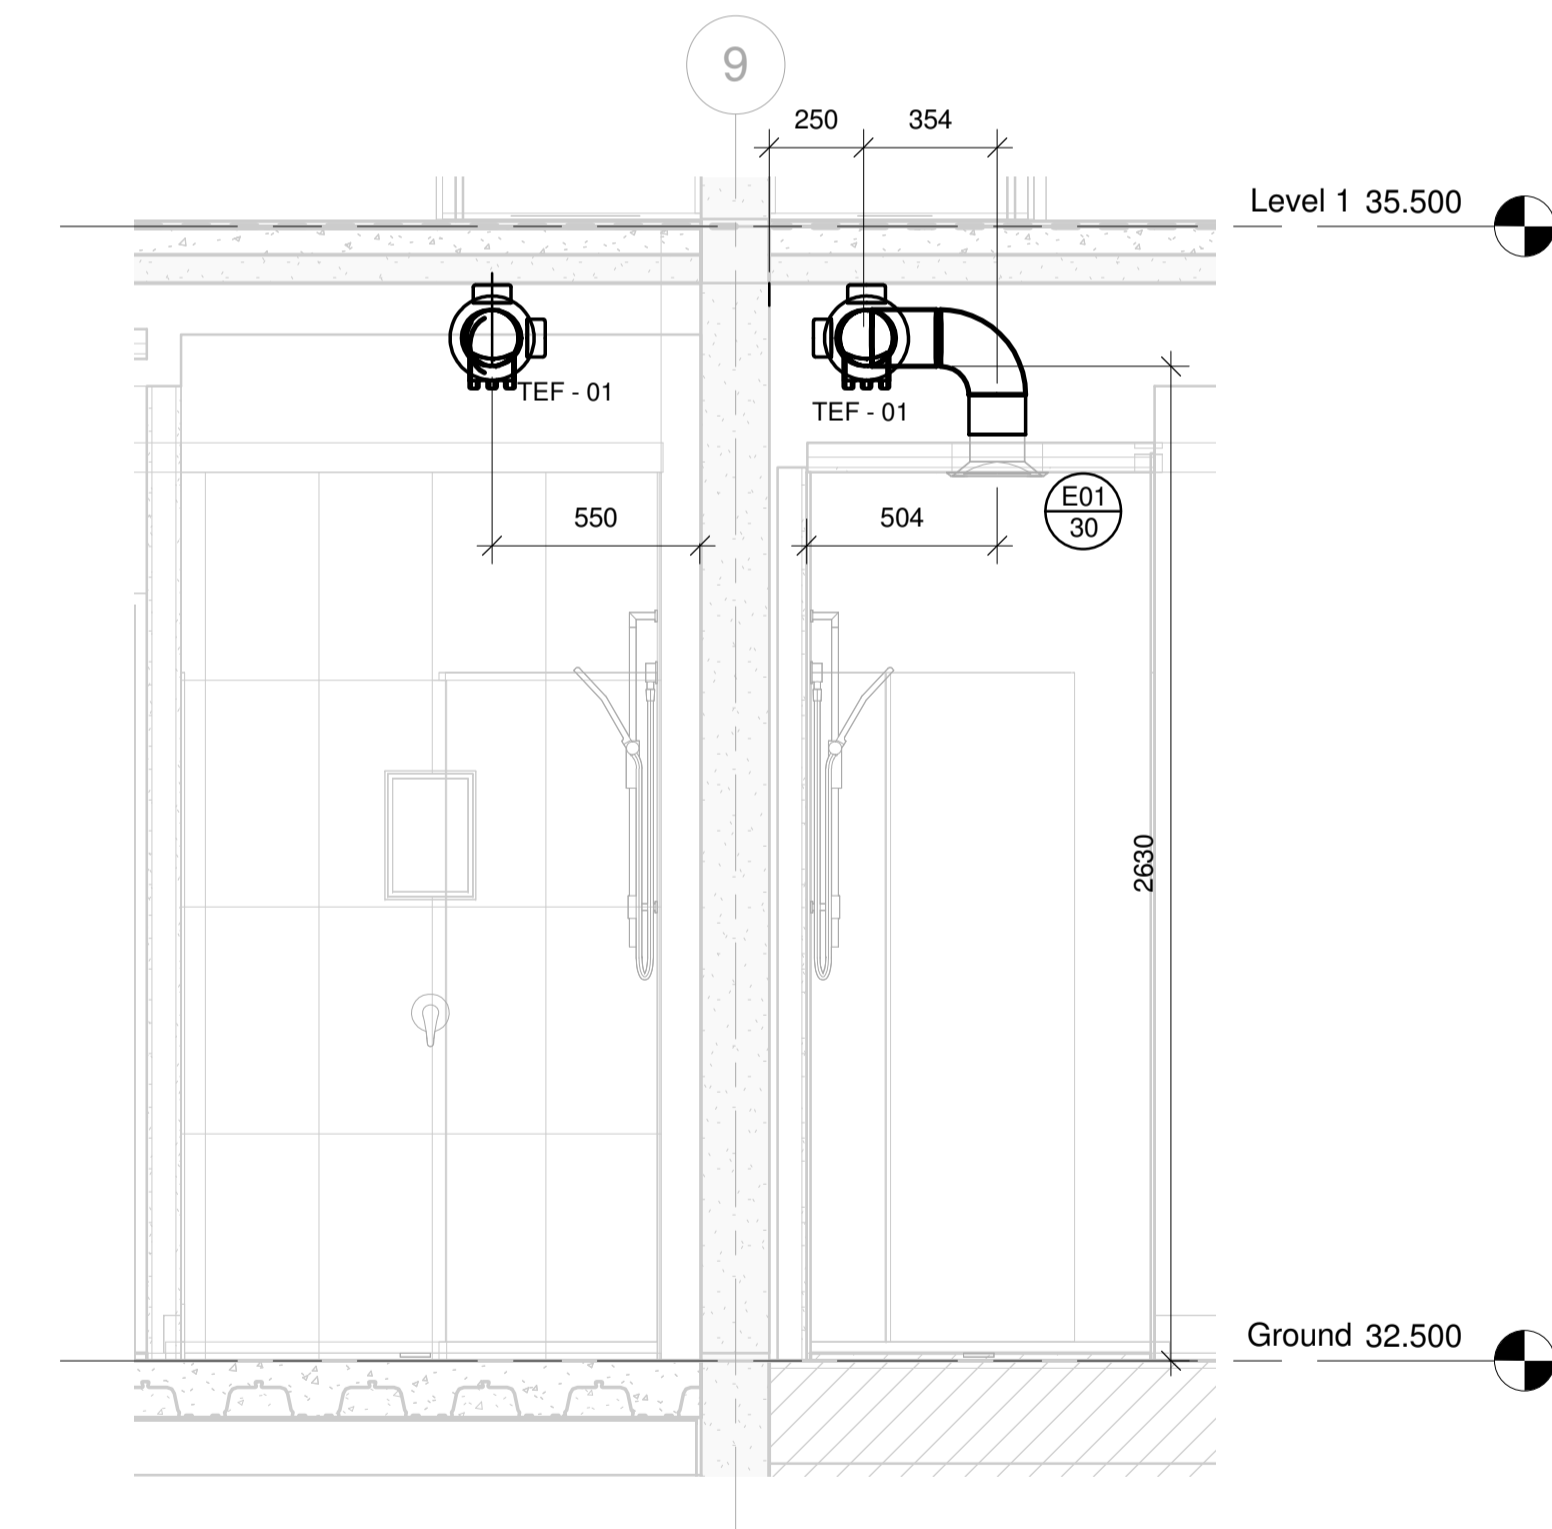

M SECTION M
M117 SCALE : 1 : 20

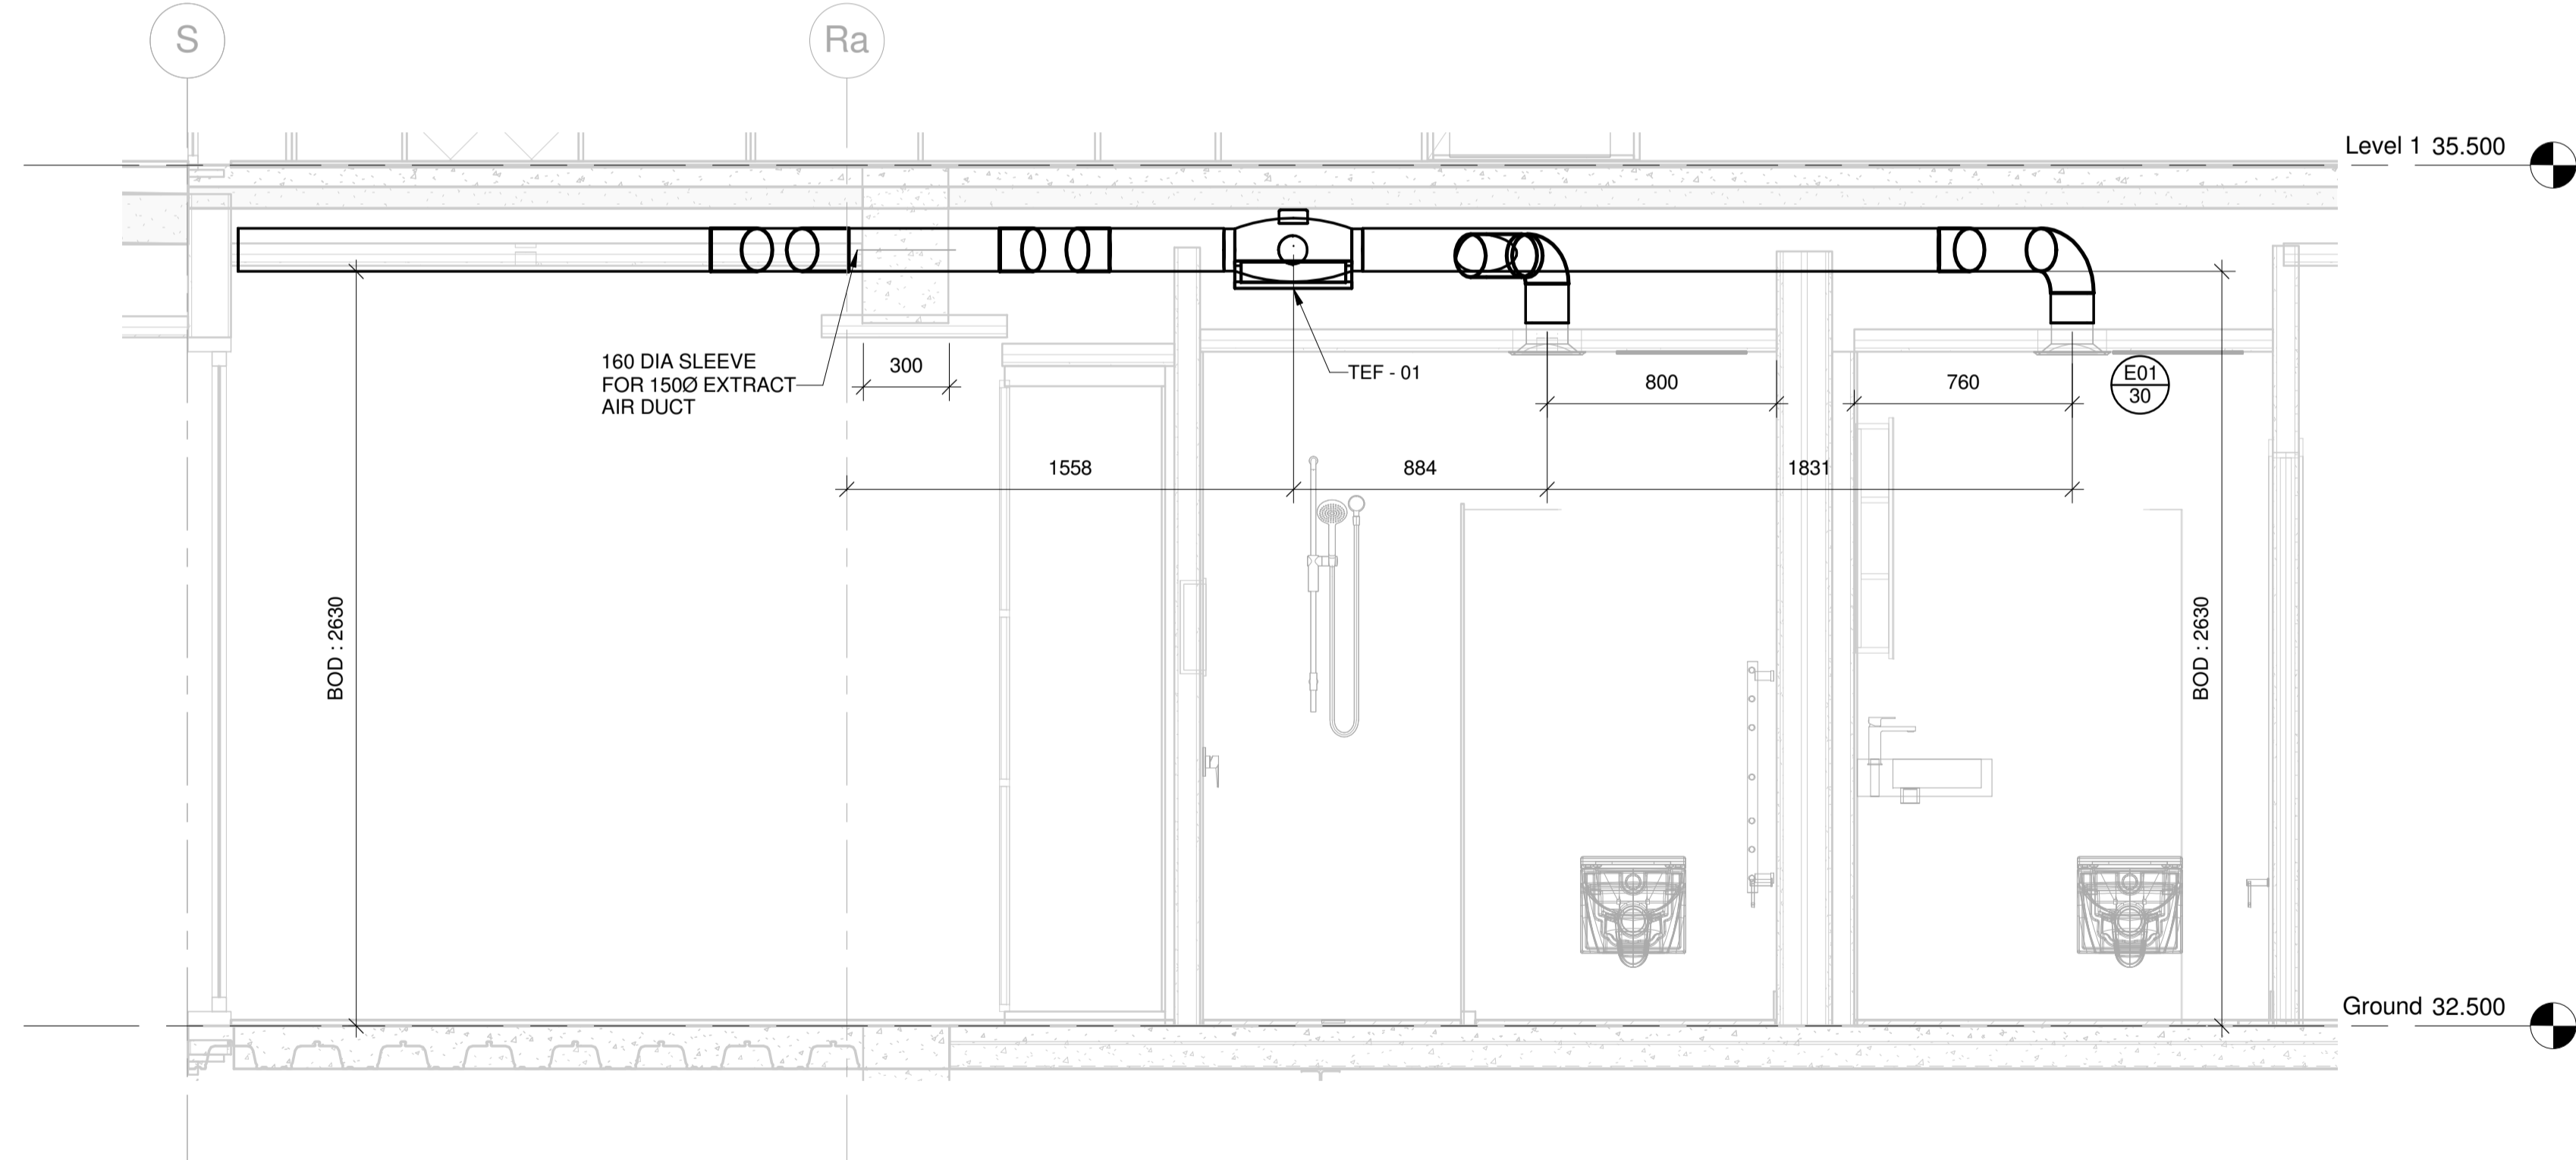

N SECTION N
M117 SCALE : 1 : 20

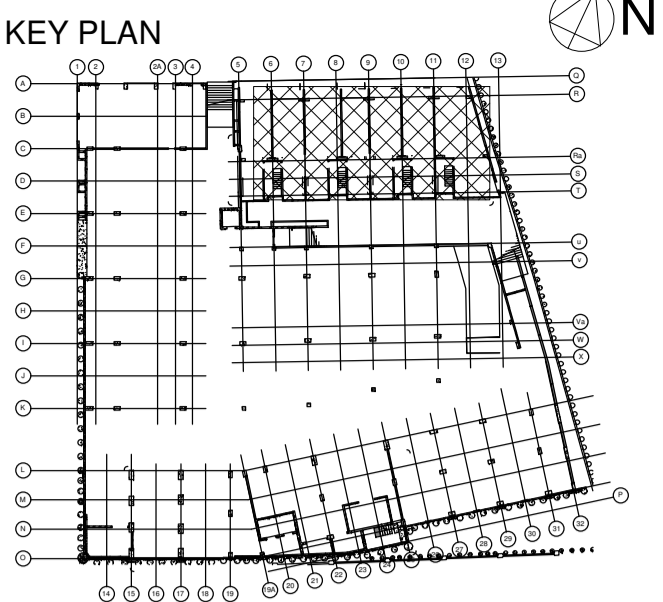

NOTE:
1. MENTIONED BOTTOM OF SLEEVES ARE REFERENCE FROM SSL

GENERAL COORDINATION NOTE:
1. HVAC COORDINATION WITH OTHER MEP SERVICES WILL BE REVIEWED UPON THE RECEIVED RESPONSE OF CASE - 4

PROJECT TITLE
UNION GREEN
APARTMENTS 39 - 47
UNION STREET
AUCKLAND CENTRAL

SHEET TITLE
GROND FLOOR BLCOK B HVAC
SECTIONS


DESIGNED IAN
DRAWN RAZIN
CHECKED TRUSHAL

PROJECT NO.
215123
SHEET NO.
M117


DISCIPLINE
MECHANICAL SERVICES

SCALE
(A1 ORIGINAL)
1 : 20
REVISION
00

00	FOR APPROVAL	06/04/18	IAN	RAZIN
REV. NO.	REVISION DESCRIPTION	REV. DATE	ENG	CAD

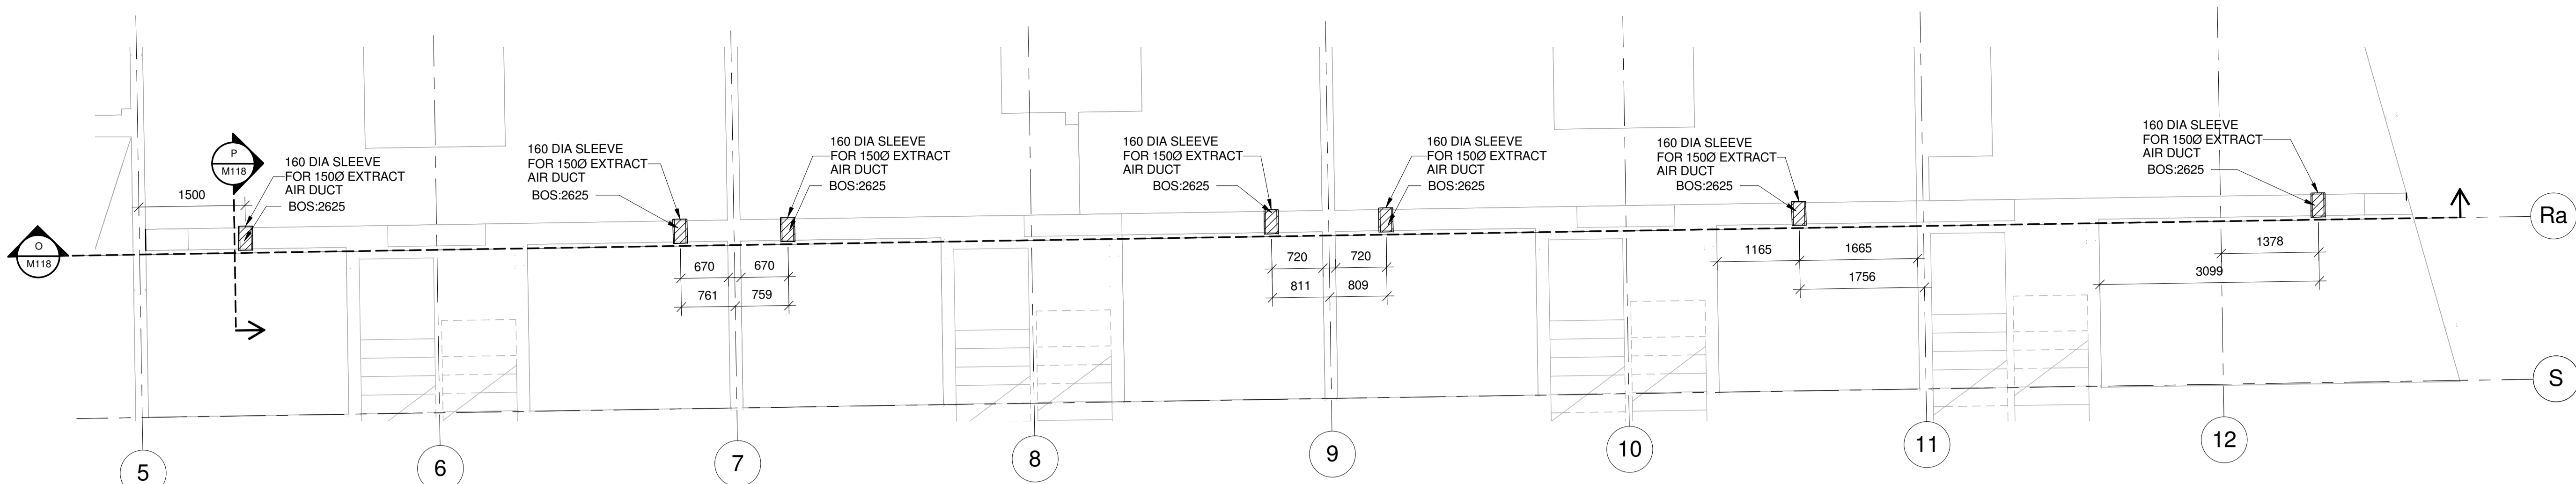


9 GROUND FLOOR BLOCK B PENETRATION LAYOUT
M118 SCALE : 1 : 50

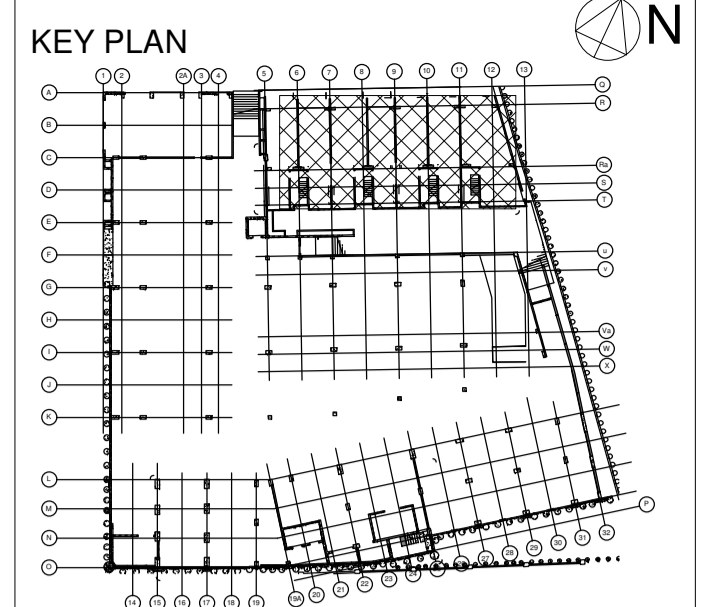


NOTE:-
1. MENTIONED BOTTOM OF SLEEVES ARE REFERENCE FROM SSL

GENERAL COORDINATION NOTE:
1. HVAC COORDINATION WITH OTHER MEP SERVICES WILL BE REVIEWED UPON THE RECEIVED RESPONSE OF CASE - 4

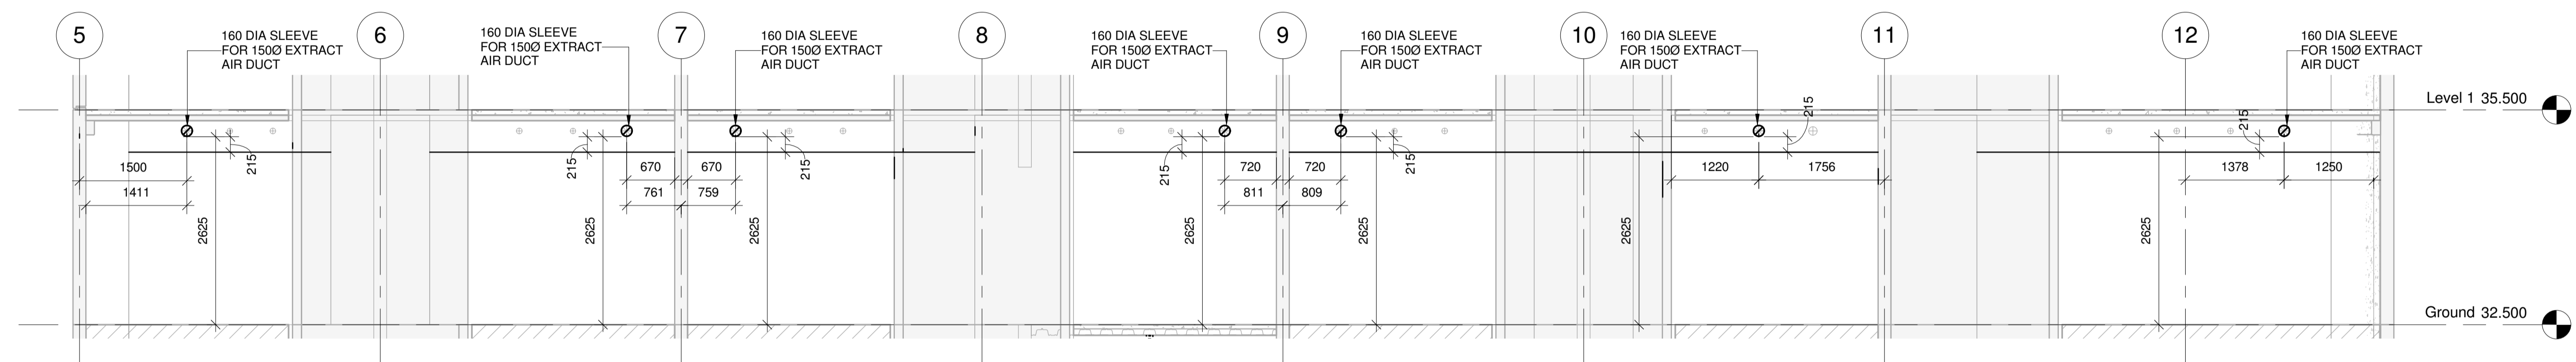

O SECTION O
M118 SCALE : 1 : 50

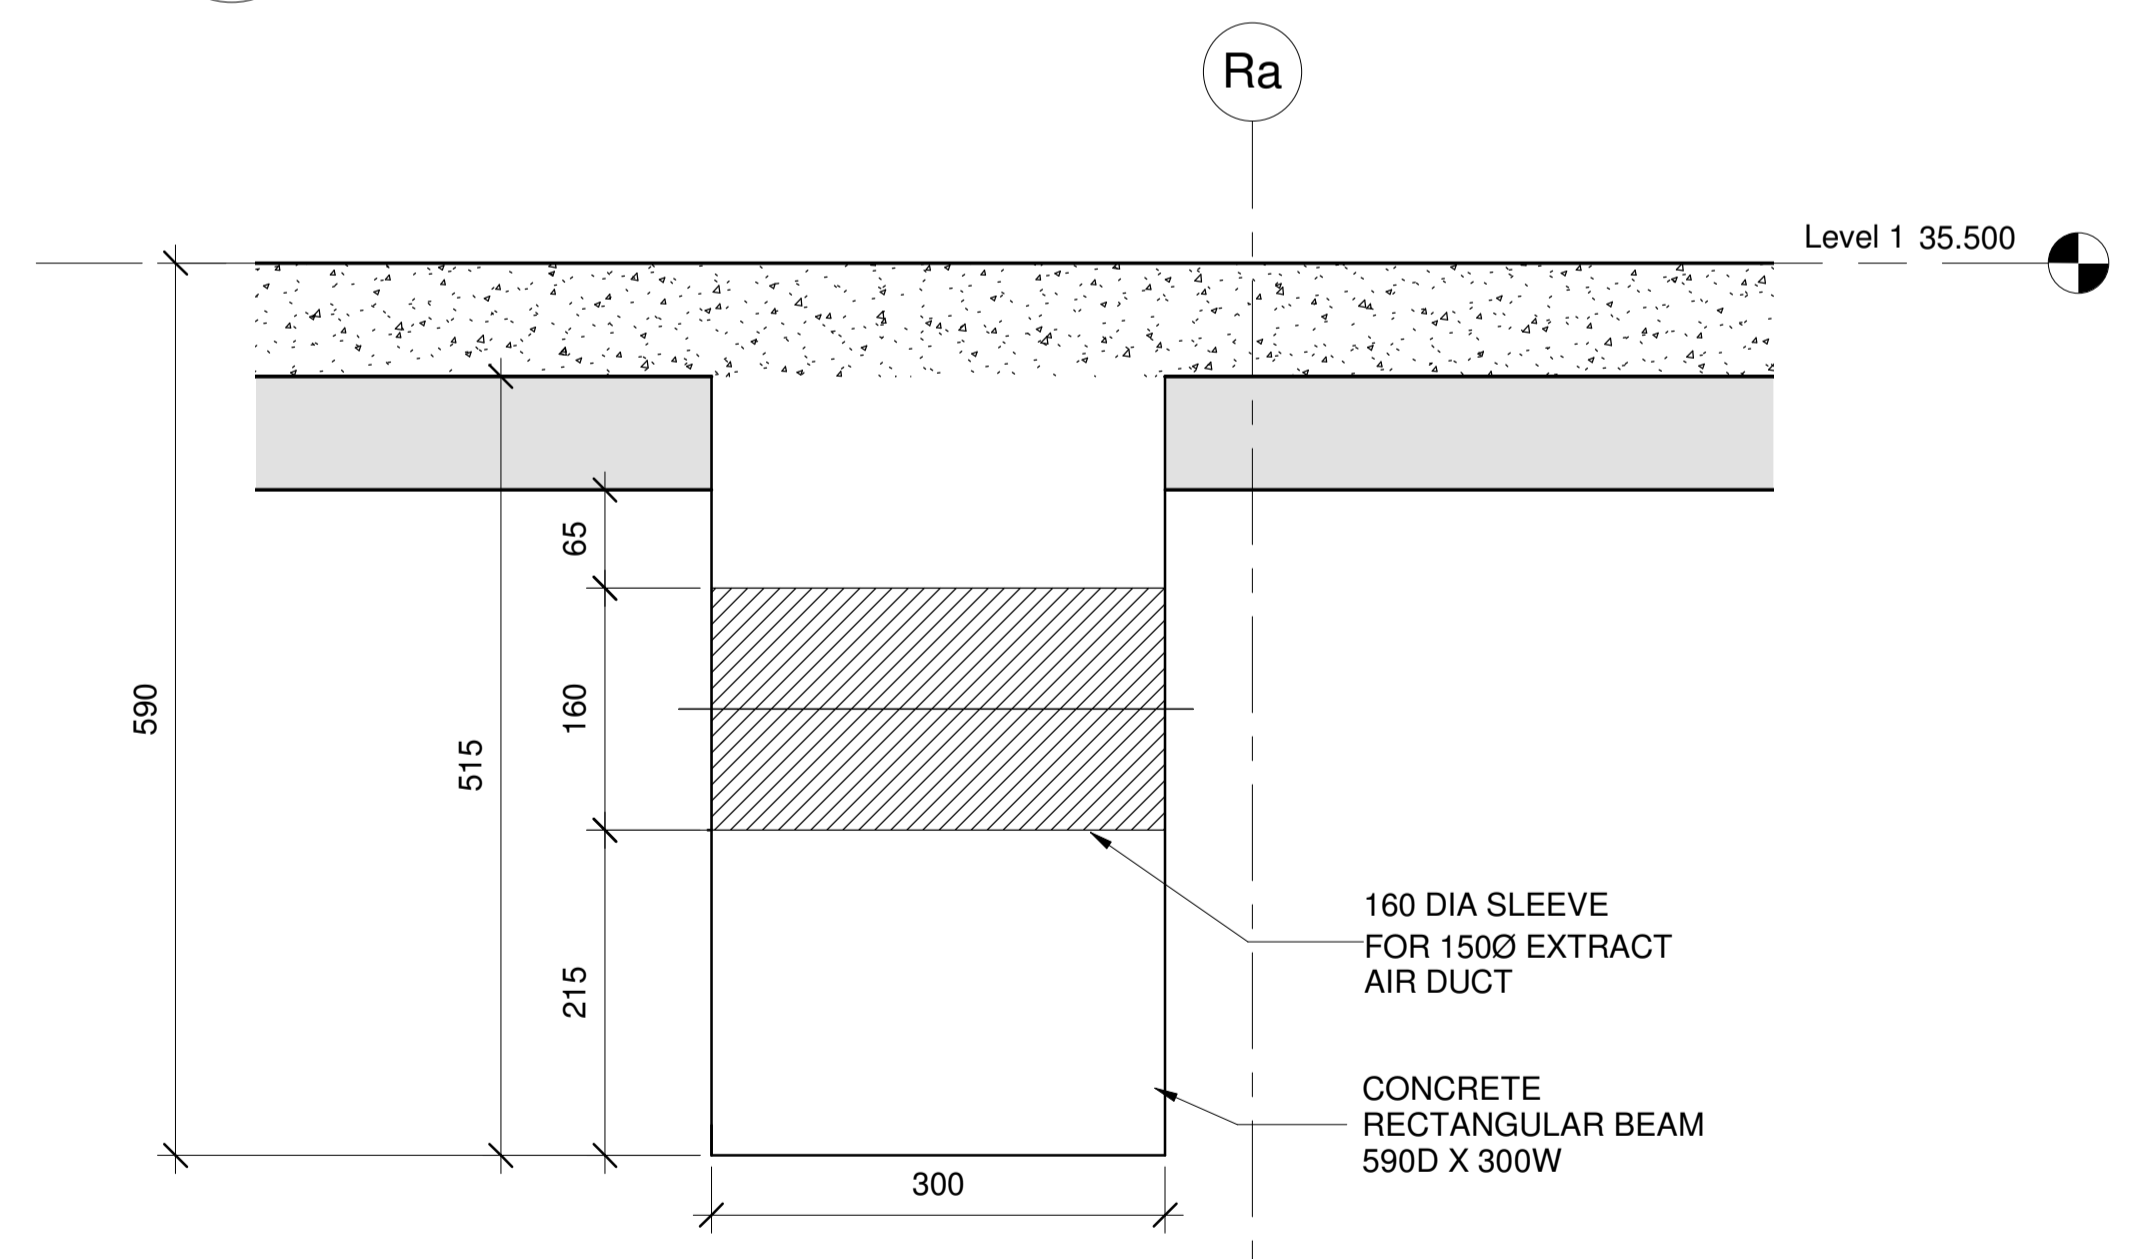

P SECTION P (TYP.)
M118 SCALE : 1 : 5

PROJECT TITLE UNION GREEN APARTMENTS 39 - 47 UNION STREET AUCKLAND CENTRAL	SHEET TITLE GROUND FLOOR BLOCK B PENETRATION LAYOUT & SECTIONS	DESIGNED	IAN	PROJECT NO. 215123	SHEET NO. M118
		DRAWN	RAZIN		
		CHECKED	TRUSHAL		
		DISCIPLINE MECHANICAL SERVICES	SCALE (A1 ORIGINAL) As indicated	REVISION 00	

00	FOR APPROVAL	06/04/18	IAN	RAZIN
REV. NO.	REVISION DESCRIPTION	REV. DATE	ENG	CAD