

KEY PLAN


NOTE:-

- MENTIONED BOTTOM OF SLEEVES ARE REFERENCE FROM SSL


GENERAL COORDINATION NOTE:

- HVAC COORDINATION WITH OTHER MEP SERVICES WILL BE REVIEWED UPON THE RECEIVED RESPONSE OF CASE - 4

10 GROUND FLOOR HVAC LAYOUT BLOCK D
M119 SCALE : 1 : 50

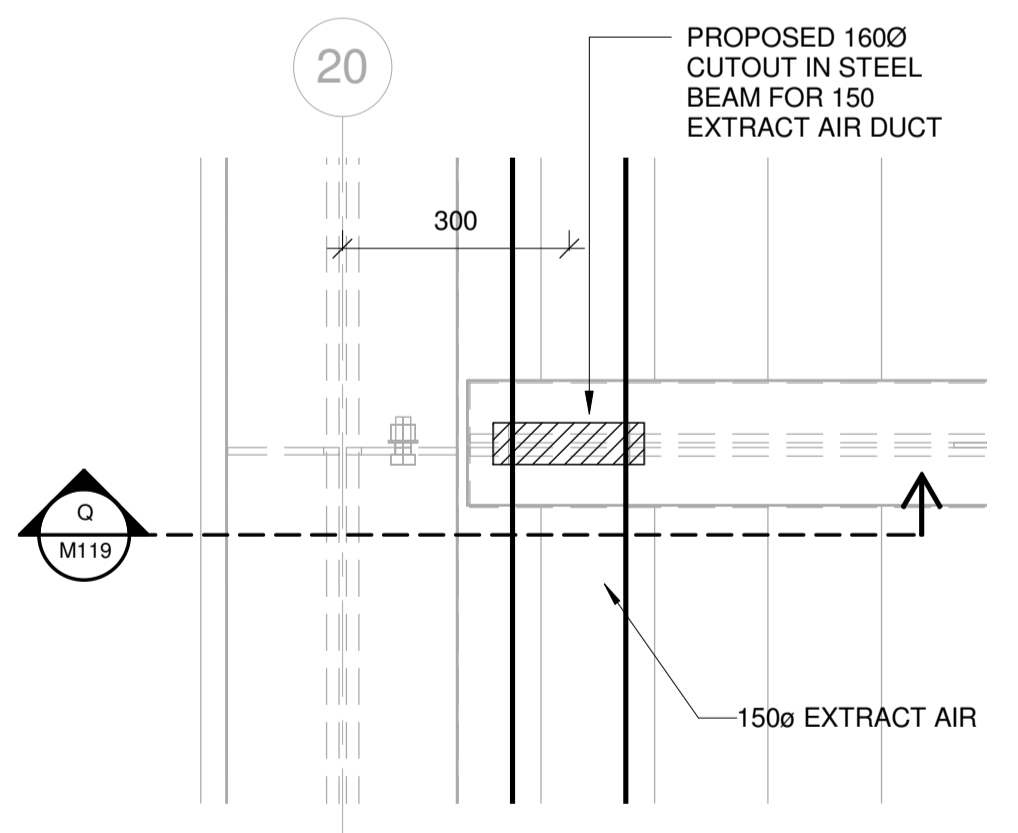


11 PROPOSED CUTOUT ENLARGE VIEW
M119 SCALE : 1 : 10

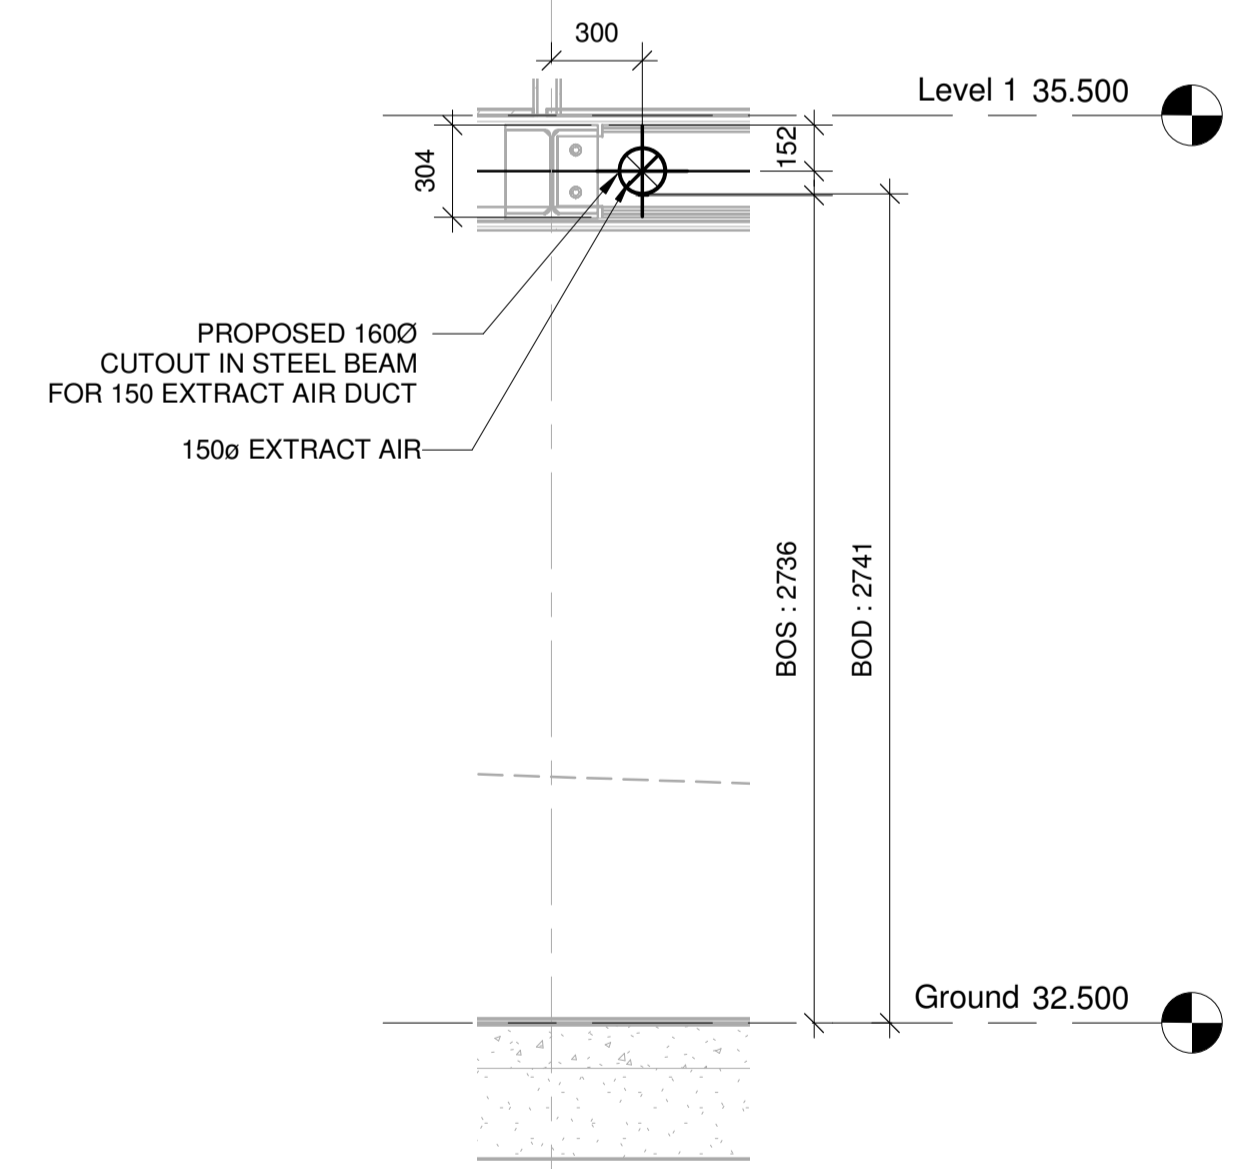


Q SECTION Q
M119 SCALE : 1 : 25


PROJECT TITLE UNION GREEN APARTMENTS 39 - 47 UNION STREET AUCKLAND CENTRAL	SHEET TITLE GROUND FLOOR BLOCK D HVAC LAYOUT	DESIGNED	IAN	PROJECT NO. 215123	SHEET NO. M119	
		DRAWN	RAZIN			
		CHECKED	TRUSHAL	SCALE (A1 ORIGINAL) As indicated	REVISION 00	
		DISCIPLINE MECHANICAL SERVICES				
00 FOR APPROVAL	06/04/18	IAN	RAZIN			
REV. NO.	REVISION DESCRIPTION	REV. DATE	ENG	CAD		

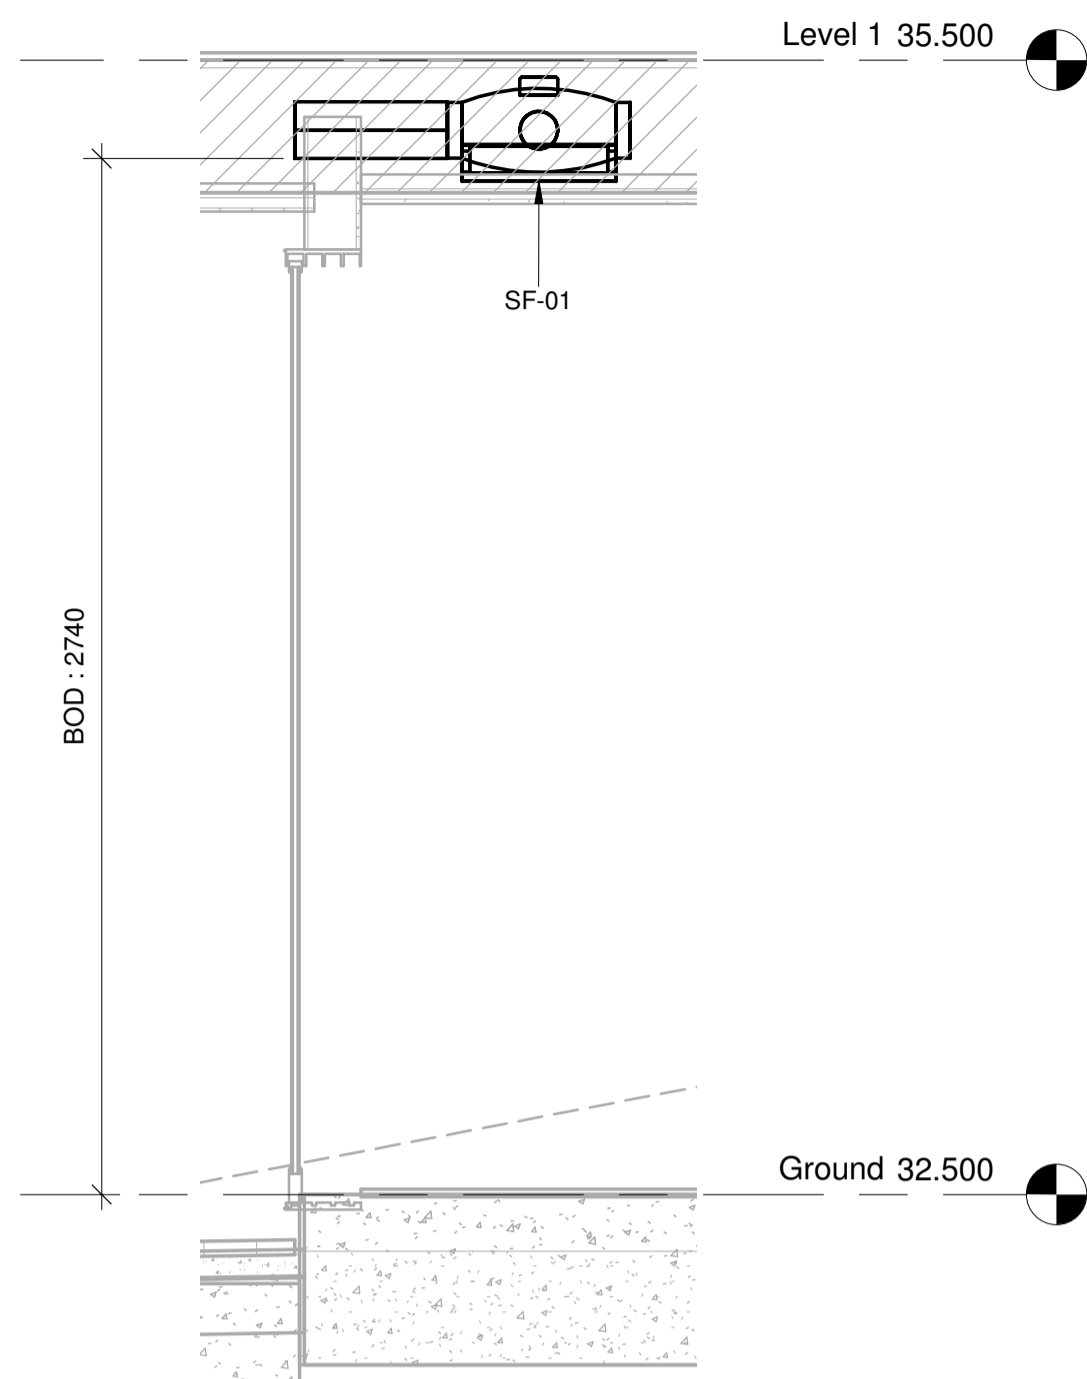

R SECTION R
M120 SCALE : 1 : 20

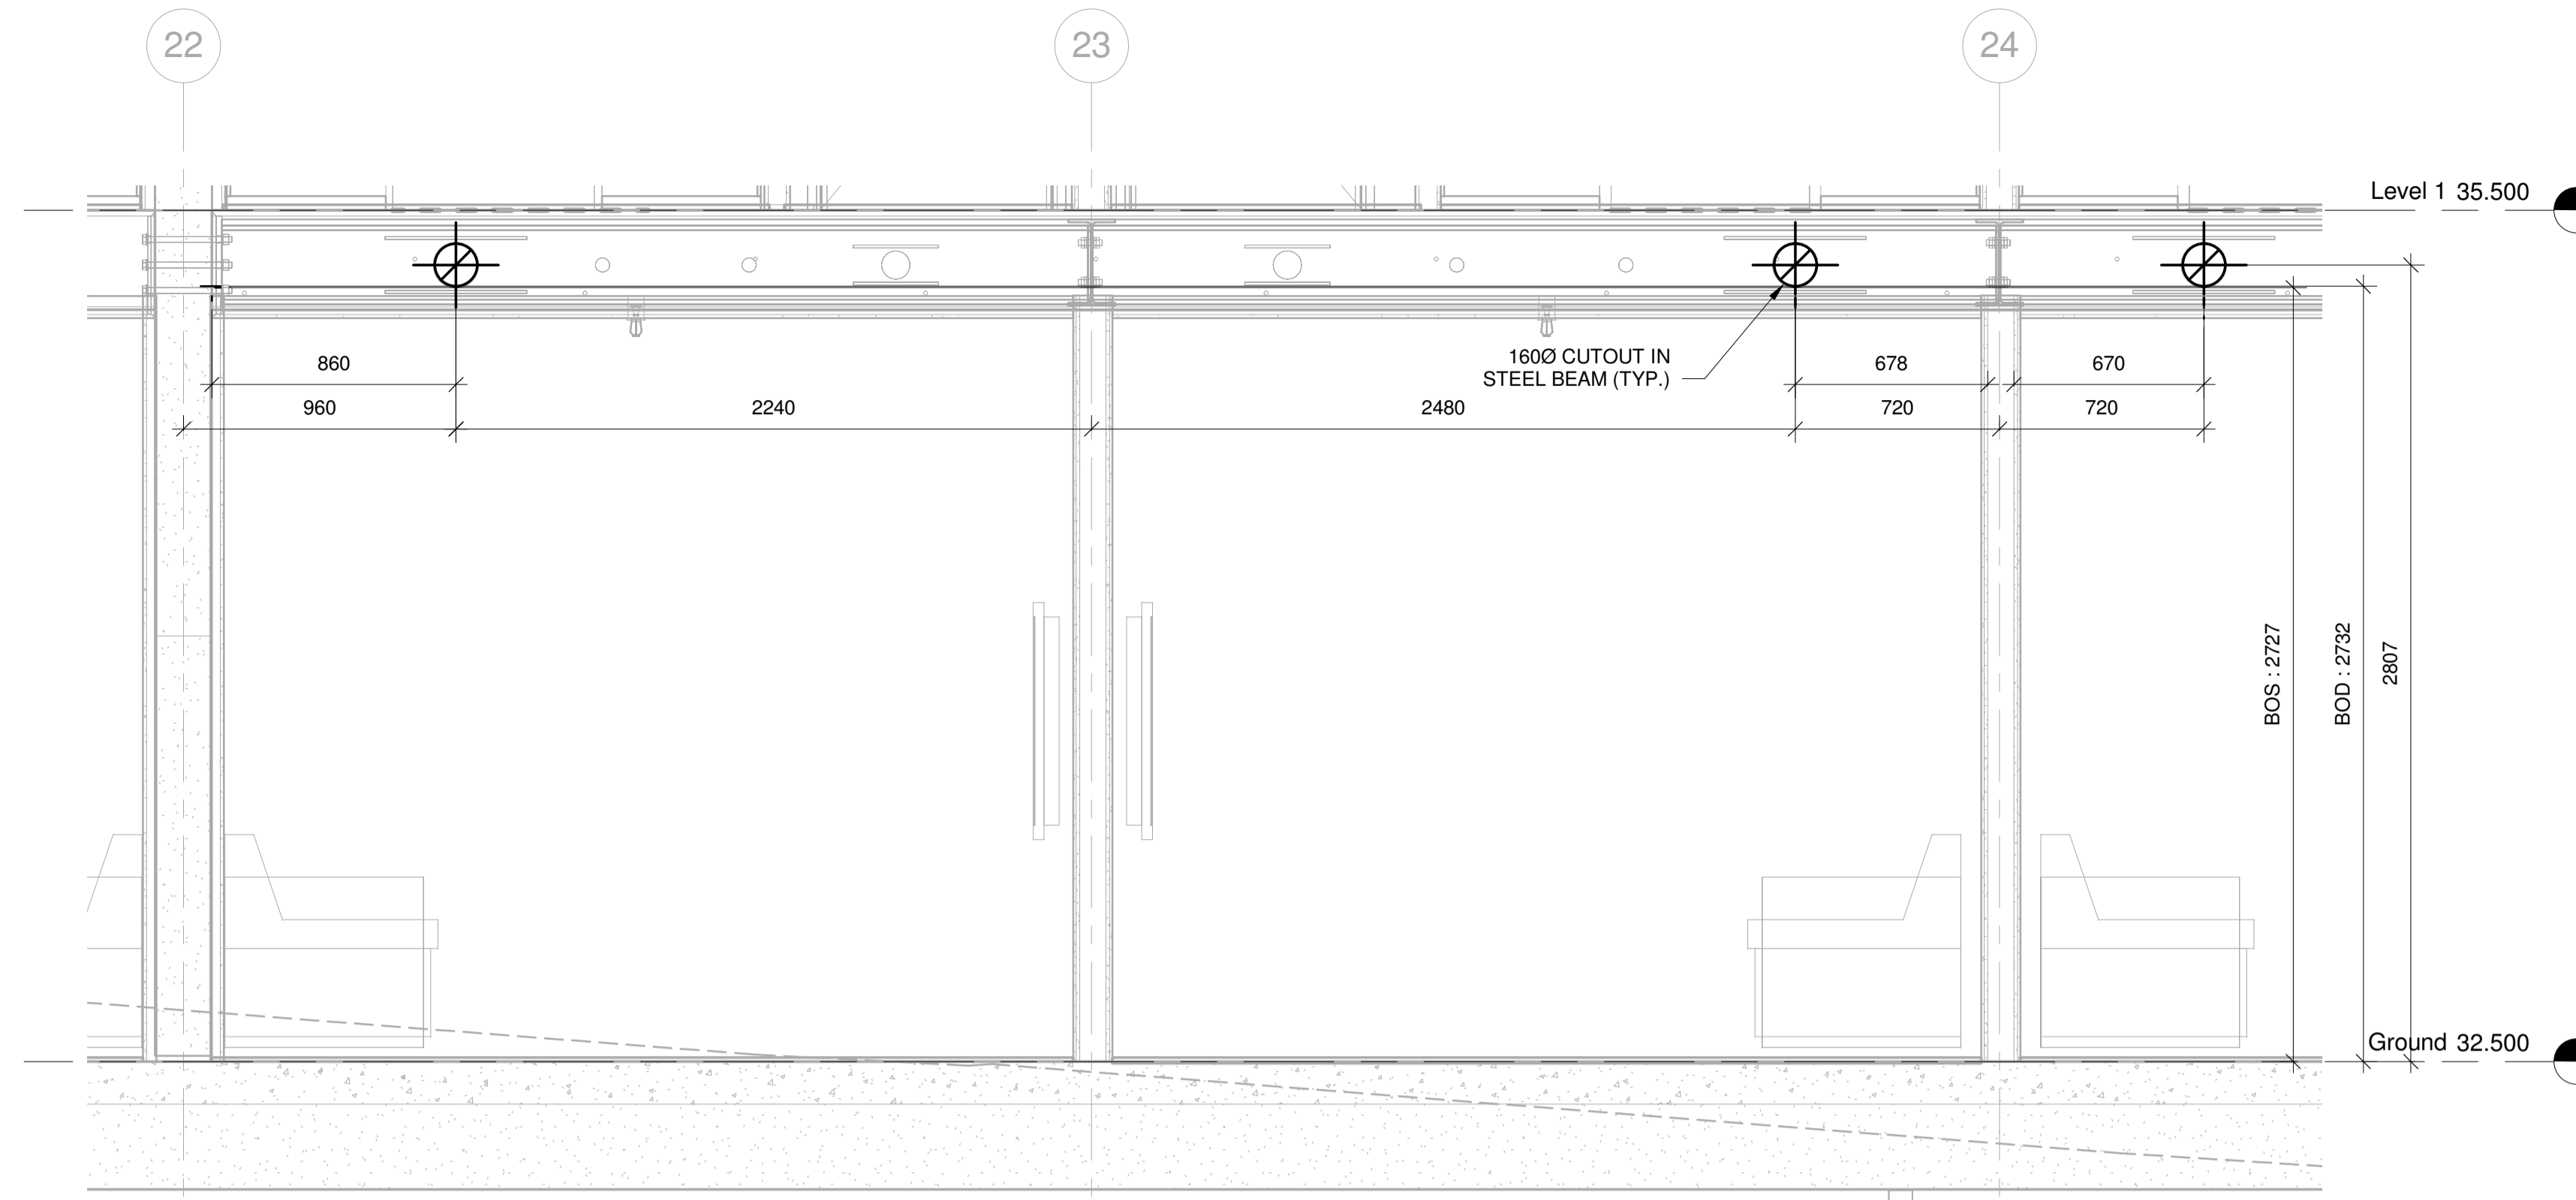


S SECTION S
M120 SCALE : 1 : 20

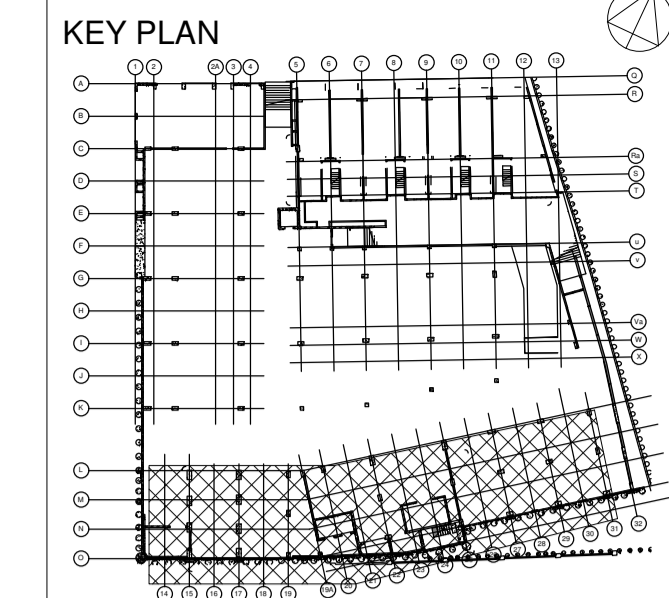


NOTE:-
1. MENTIONED BOTTOM OF SLEEVES ARE REFERENCE FROM SSL


GENERAL COORDINATION NOTE:
1. HVAC COORDINATION WITH OTHER MEP SERVICES WILL BE REVIEWED UPON THE RECEIVED RESPONSE OF CASE - 4

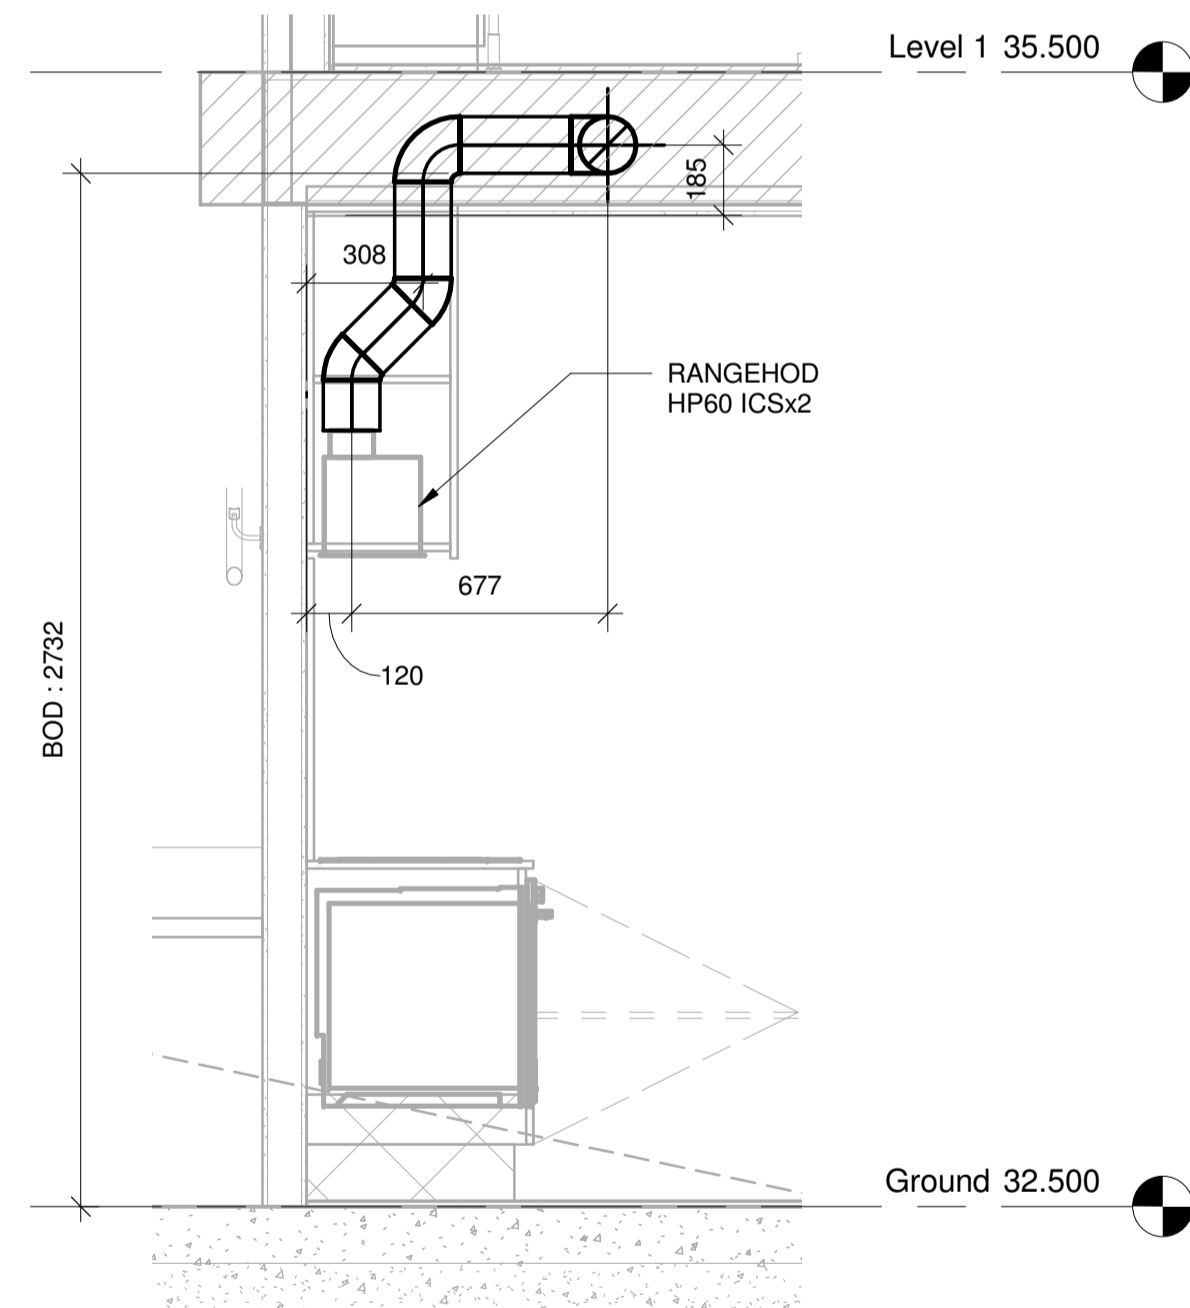

T SECTION T
M120 SCALE : 1 : 20

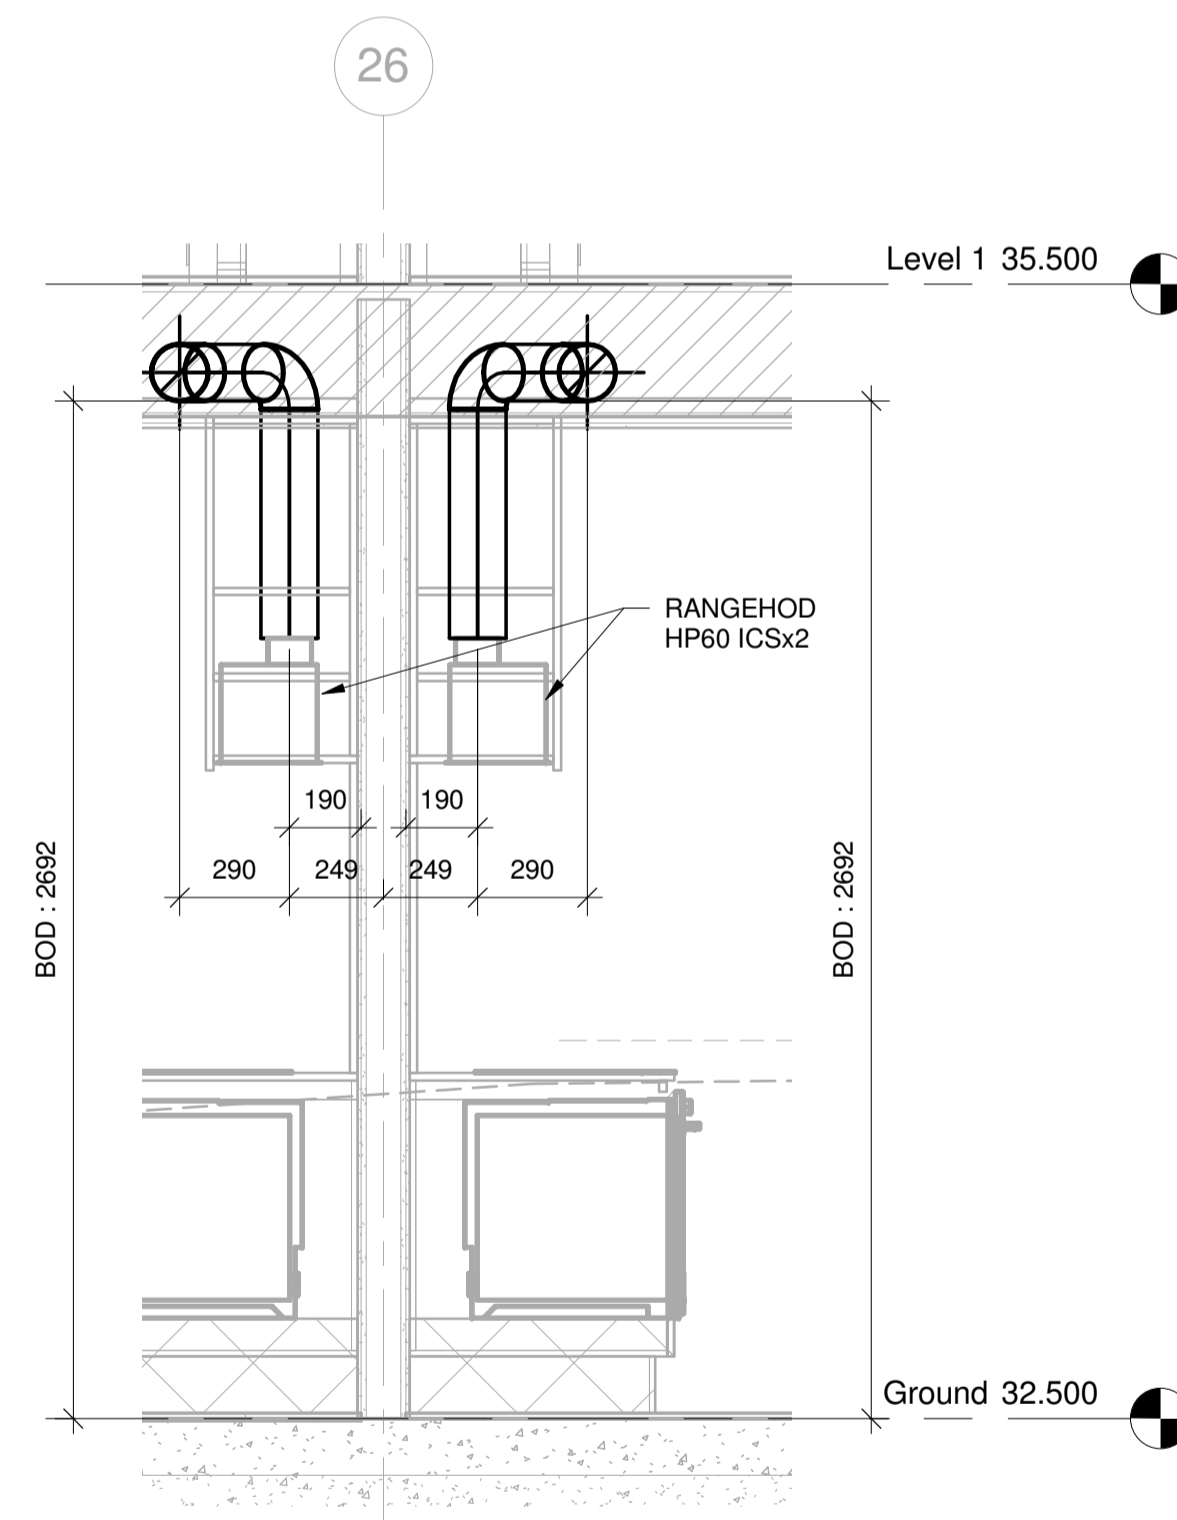

U SECTION U
M120 SCALE : 1 : 20

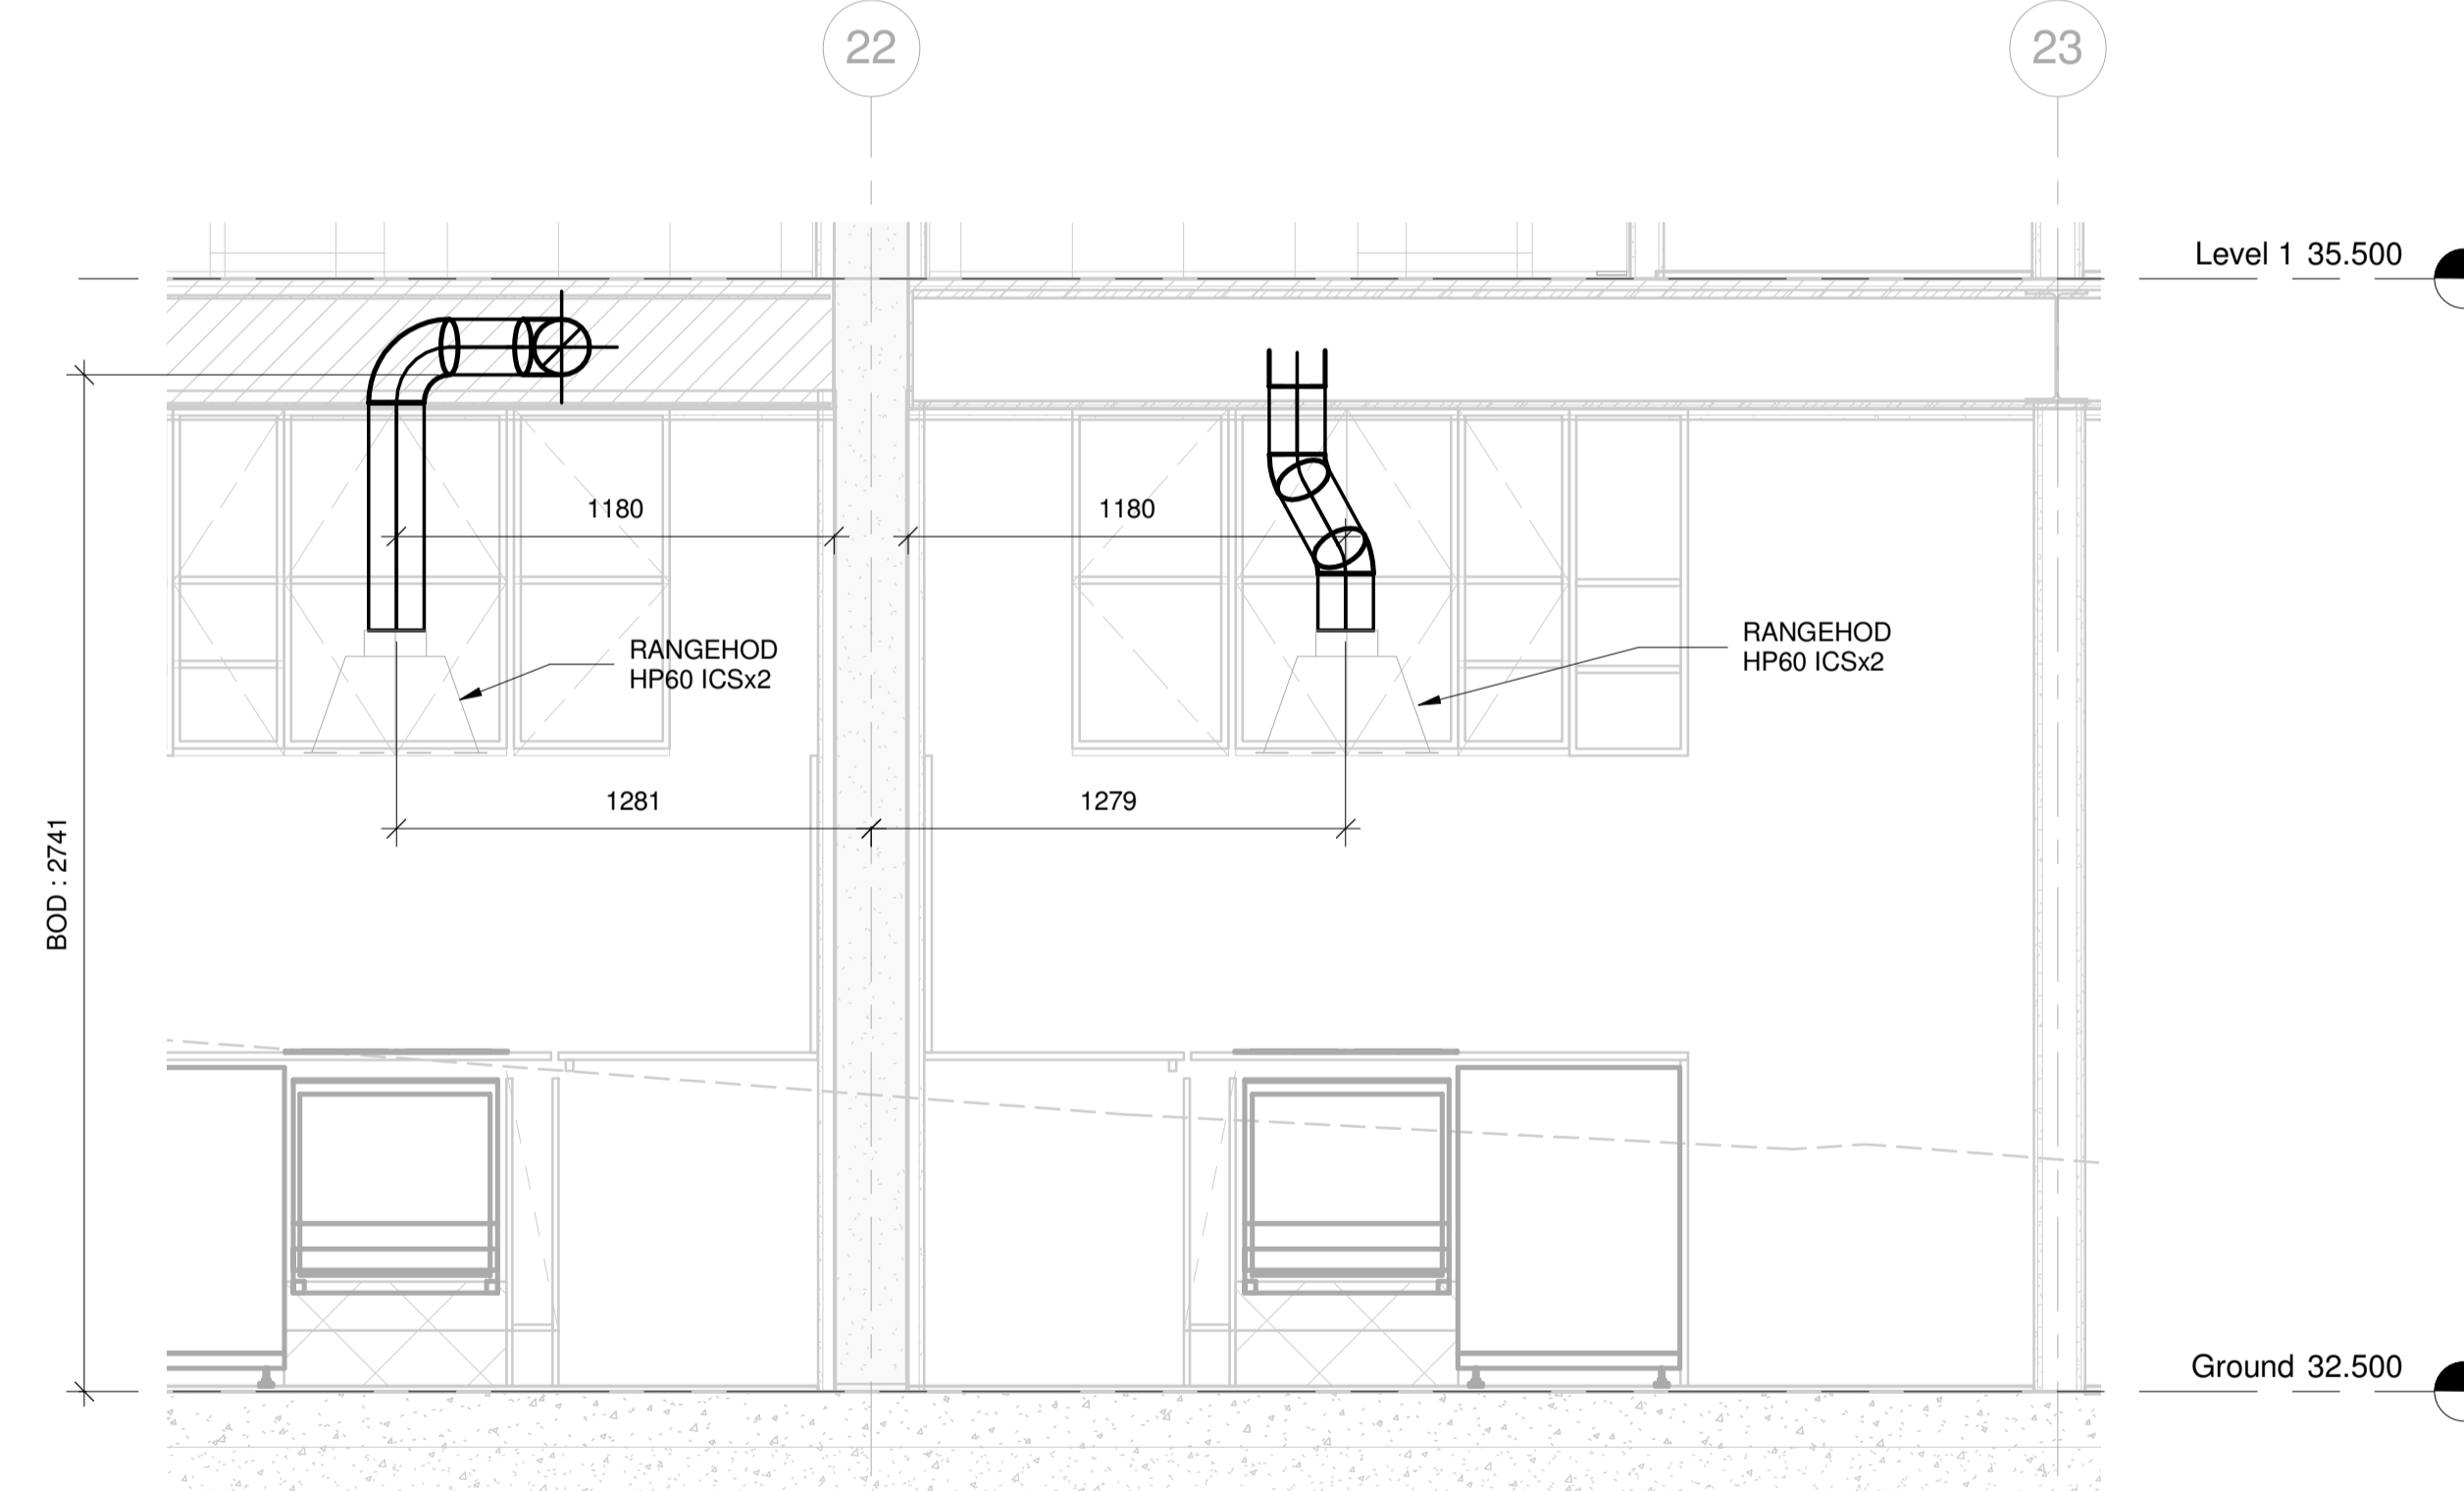

V SECTION V
M120 SCALE : 1 : 20

PROJECT TITLE UNION GREEN APARTMENTS 39 - 47 UNION STREET AUCKLAND CENTRAL	SHEET TITLE GROUND FLOOR BLOCK D HVAC SECTIONS	DESIGNED	IAN	PROJECT NO. 215123	SHEET NO. M120
		DRAWN	RAZIN		
		CHECKED	TRUSHAL		
		DISCIPLINE	MECHANICAL SERVICES	SCALE (A1 ORIGINAL) 1 : 20	REVISION 00

00	FOR APPROVAL	06/04/18	IAN	RAZIN
REV. NO.	REVISION DESCRIPTION	REV. DATE	ENG	CAD